




Planning Committee B

23/00283/FUL

Fulford Flood Alleviation Scheme Fulford Ings and Playing Fields

ISO A1 (480mm x 640mm)
 Approved: BR
 Checked: VC
 Designer: KT
 Project Management/Title:

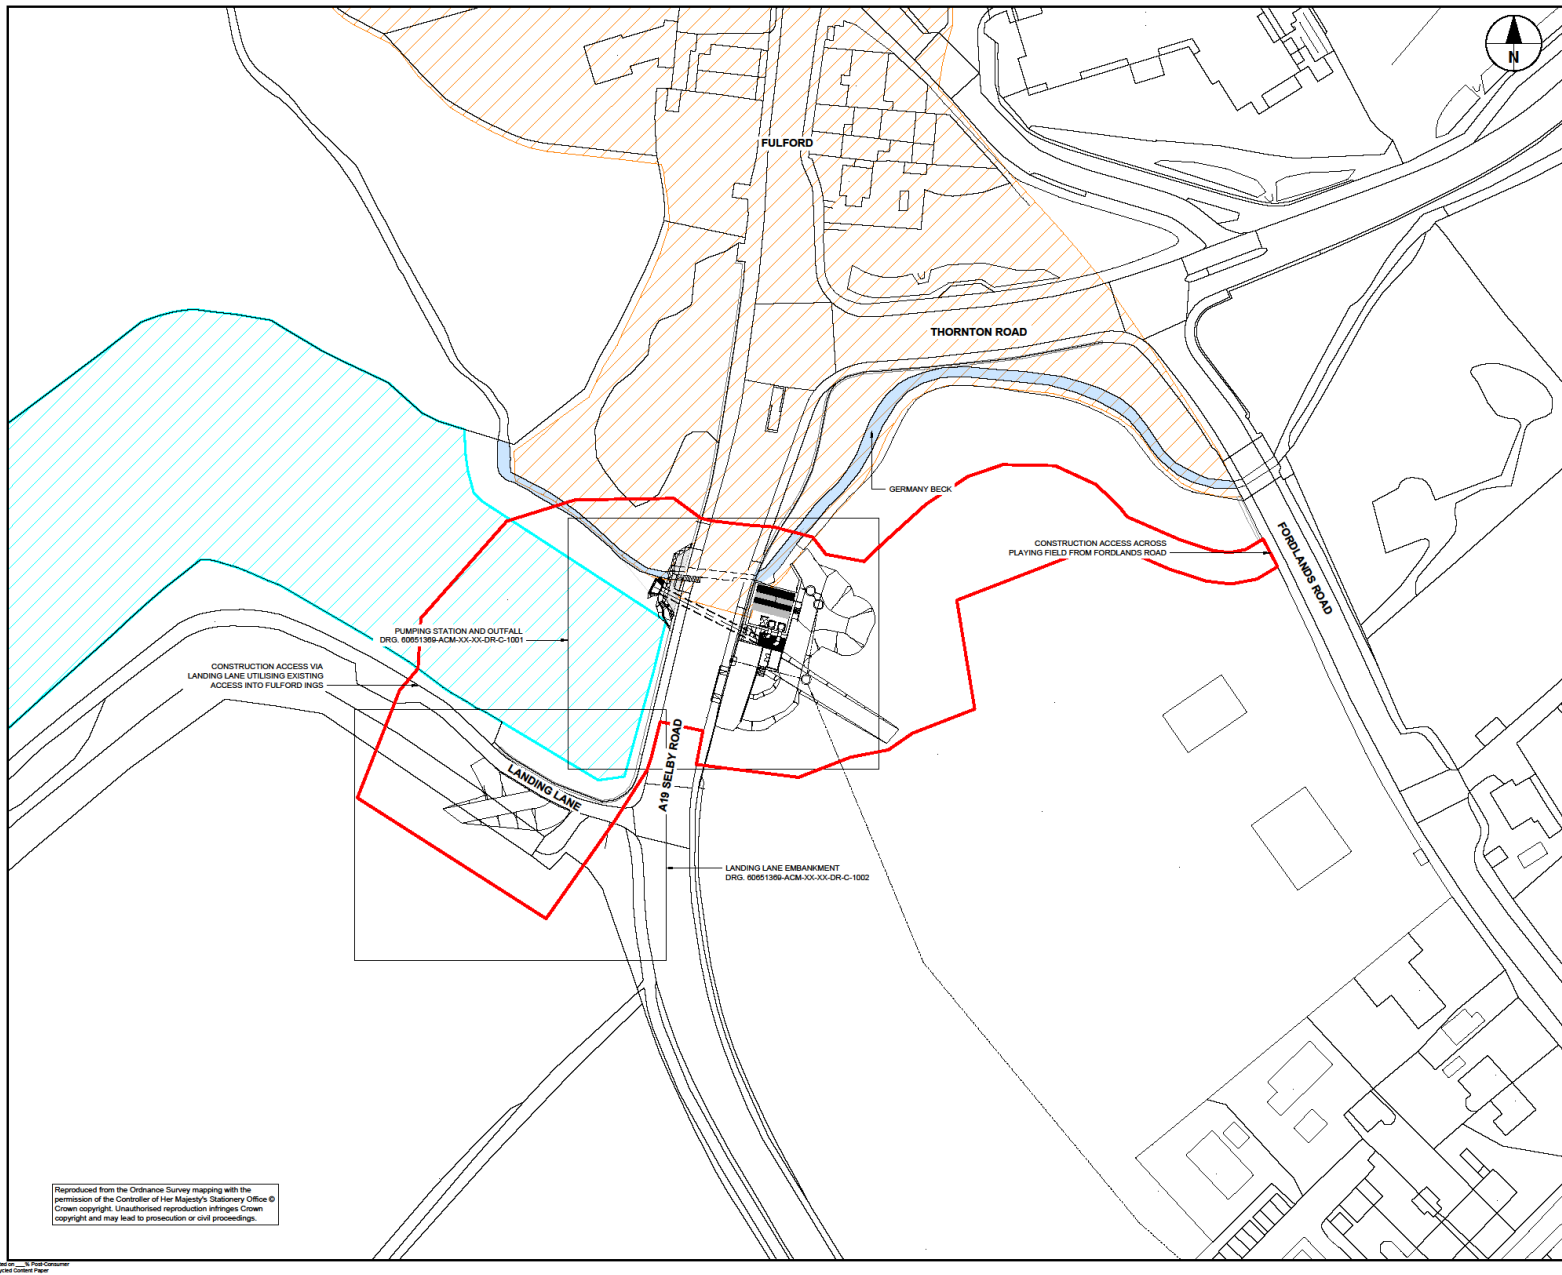

Reproduced from the Ordnance Survey mapping with the permission of the Controller of Her Majesty's Stationary Office © Crown copyright. Unauthorised reproduction infringes Crown copyright and may lead to prosecution or civil proceedings.



 
PROJECT
 GERMANY BECK
 FLOOD ALLEVIATION
 SCHEME

CLIENT
 CITY OF YORK COUNCIL
 West Offices, Station Rise
 York, YO1 6GA

CONSULTANT
 AECOM
 2 City Walk,
 Leeds, LS11 9AR
 +44(0)-113-301-8400 tel.
 www.aecom.com

- NOTES**
- DO NOT SCALE FROM THIS DRAWING.
 - ALL DIMENSIONS IN MILLIMETRES UNLESS OTHERWISE STATED.
 - ALL LEVELS IN METRES ABOVE ORDNANCE DATUM.
 - THE FLOOD DEFENCE LEVEL OF 10.04 HAS BEEN CALCULATED FROM THE OUSE WASHLANDS MODEL 100 YEAR + 2.4% CLIMATE CHANGE ALL OUNAGE FLOOD LEVEL OF 8.82 WITH 0.2% OF UNCERTAINTY.

- LEGEND**
- SITE BOUNDARY
 - CONSERVATION AREA
 - SITE OF SPECIAL SCIENTIFIC INTEREST



ISSUE/REVISION


NO	DATE	DESCRIPTION
PO1	02/12/2022	FOR PLANNING
VR1		

PROJECT NUMBER
 60651369

SHEET TITLE
 GENERAL ARRANGEMENT
 SITE PLAN

SHEET NUMBER
 60651369-ACM-XX-XX-DR-C-1000

General site arrangement

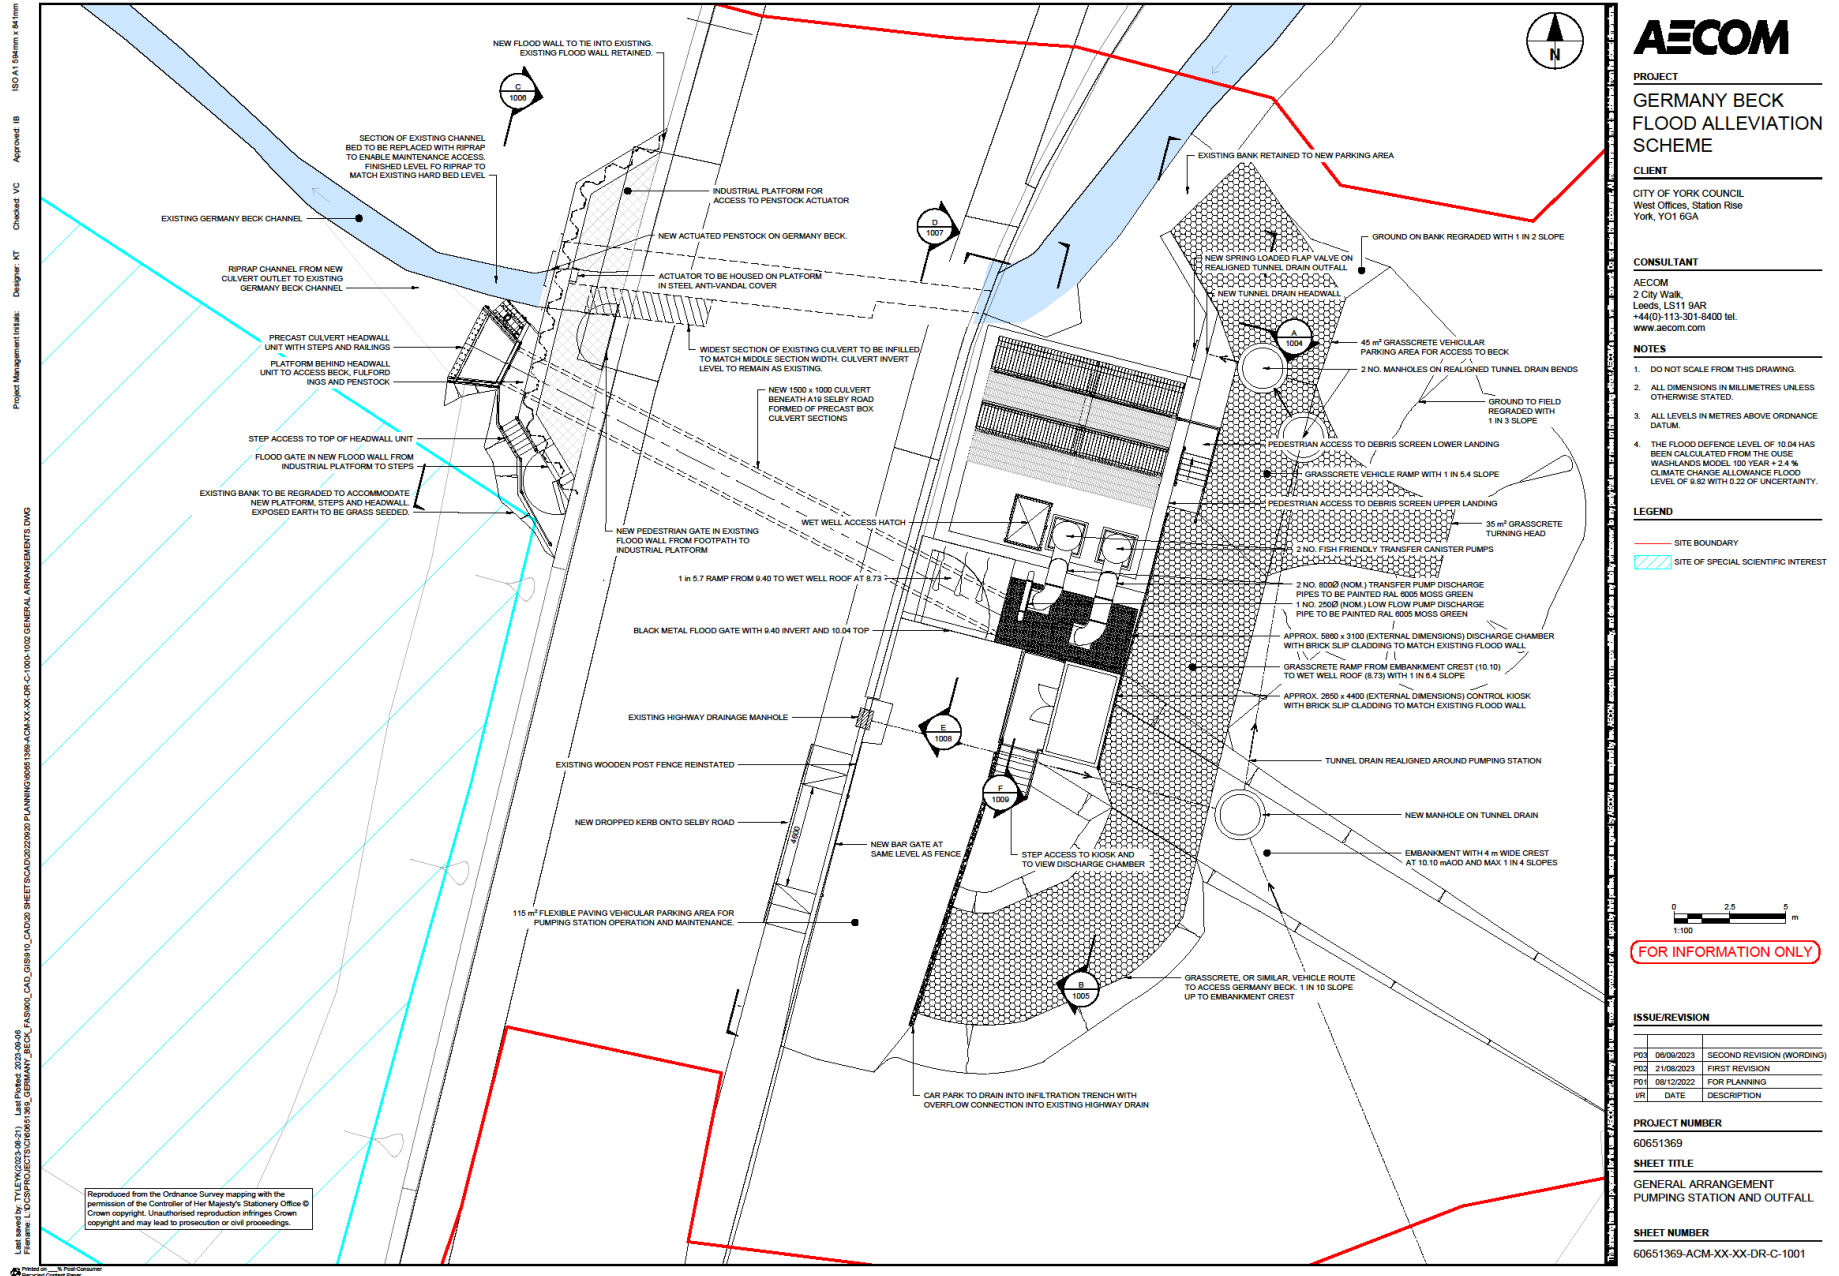

ISO A1 (84mm x 44mm)
 Approved 18
 Checked VC
 Designer RT
 Project Management Initials:
 Designer VC

ISO A1 (84mm x 44mm)
 Approved 18
 Checked VC
 Designer RT
 Project Management Initials:
 Designer VC

ISO A1 (84mm x 44mm)
 Approved 18
 Checked VC
 Designer RT
 Project Management Initials:
 Designer VC

- NOTES
- DO NOT SCALE FROM THIS DRAWING.
 - ALL DIMENSIONS IN MILLIMETRES UNLESS OTHERWISE STATED.
 - ALL LEVELS IN METRES ABOVE ORDNANCE DATUM.
 - THE FLOOD DEFENCE LEVEL OF 10.04 HAS BEEN CALCULATED FROM THE OUSE WASHLANDS MODEL 100 YEAR + 24% CLIMATE CHANGE ALLOWANCE FLOOD LEVEL OF 9.82 WITH 0.22 OF UNCERTAINTY.

- LEGEND
- SITE BOUNDARY
 - SITE OF SPECIAL SCIENTIFIC INTEREST

0 2 4 6 m
 1:100


FOR INFORMATION ONLY

ISSUE/REVISION	
PO1	06/06/2023 SECOND REVISION (WORDING)
PO2	21/08/2023 FIRST REVISION
PO1	08/12/2022 FOR PLANNING
VR	DATE DESCRIPTION

PROJECT NUMBER
 60651369
 SHEET TITLE
 GENERAL ARRANGEMENT
 PUMPING STATION AND OUTFALL

SHEET NUMBER
 60651369-ACM-XX-DR-C-1001

Pumping station elevations from East (playing field)

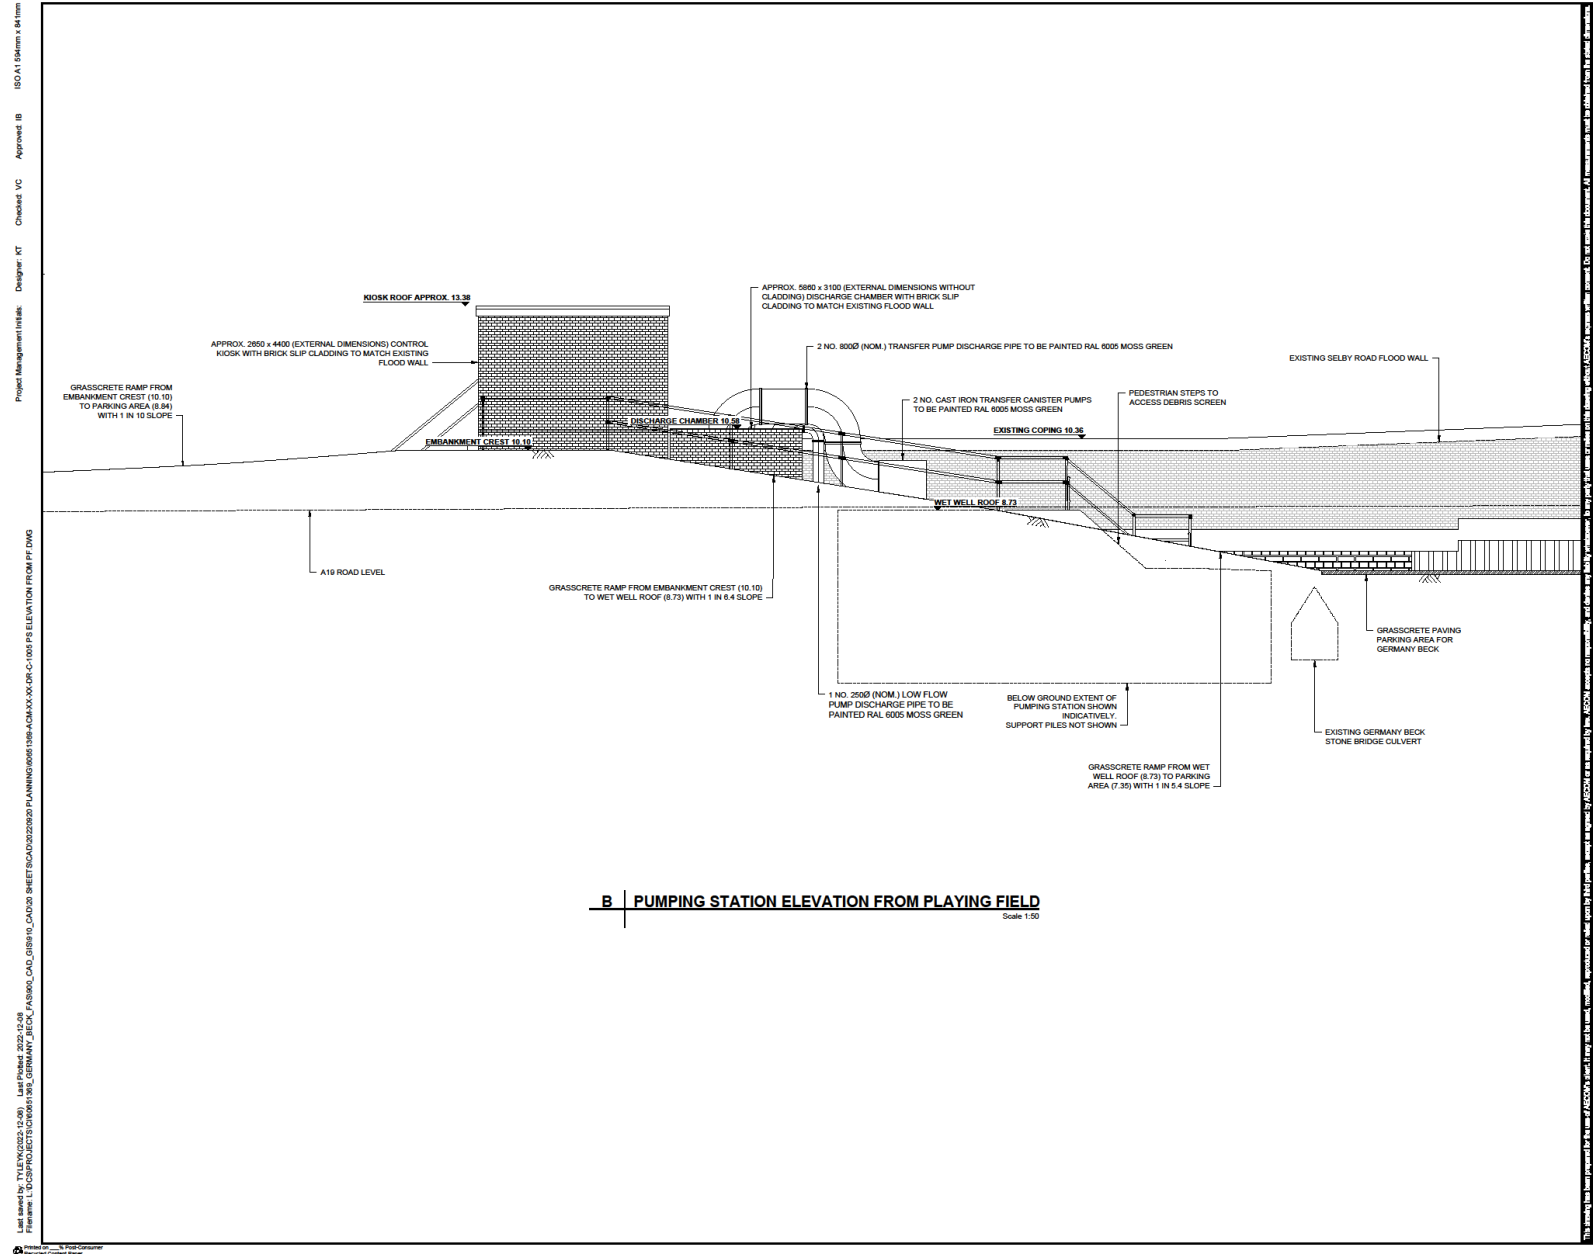

Project Management Initials: Designer: KT Checked: VC Approved: BB
 IBD A1 194mm x 64mm
 Last saved by: TYLEY\02021408 - Last Printed: 2023-02-08
 Filename: L:\DC\PROJECTS\2020\1948_GERMANY_BECK_PA\800_PA\800_CAD_GBSR_16_CAD\02_SHEET\CAD\20202020 PLANNING\0605 159-ACM-XX-XX-C-1001 PE ELEVATION FROM PF DWG



PROJECT
GERMANY BECK
FLOOD ALLEVIATION
SCHEME

CLIENT
CITY OF YORK COUNCIL
West Offices, Station Rise
York, YO1 6GA

CONSULTANT
AECOM
2 City Walk,
Leeds, LS11 9AR
+44(0)113-201-8400 tel.
www.aecom.com

- NOTES**
1. DO NOT SCALE FROM THIS DRAWING.
 2. ALL DIMENSIONS IN MILLIMETRES UNLESS OTHERWISE STATED.
 3. ALL LEVELS IN METRES ABOVE ORDNANCE DATUM.



FOR INFORMATION ONLY

ISSUE/REVISION


PN	DATE	FOR PLANNING
01	08/12/2022	FOR PLANNING
VR	DATE	DESCRIPTION

PROJECT NUMBER
6051369

SHEET TITLE
PUMPING STATION ELEVATION
LOOKING WEST FROM PLAYING FIELD


SHEET NUMBER
6051369-ACM-XX-XX-C-DR-1005

Pumping station North elevations

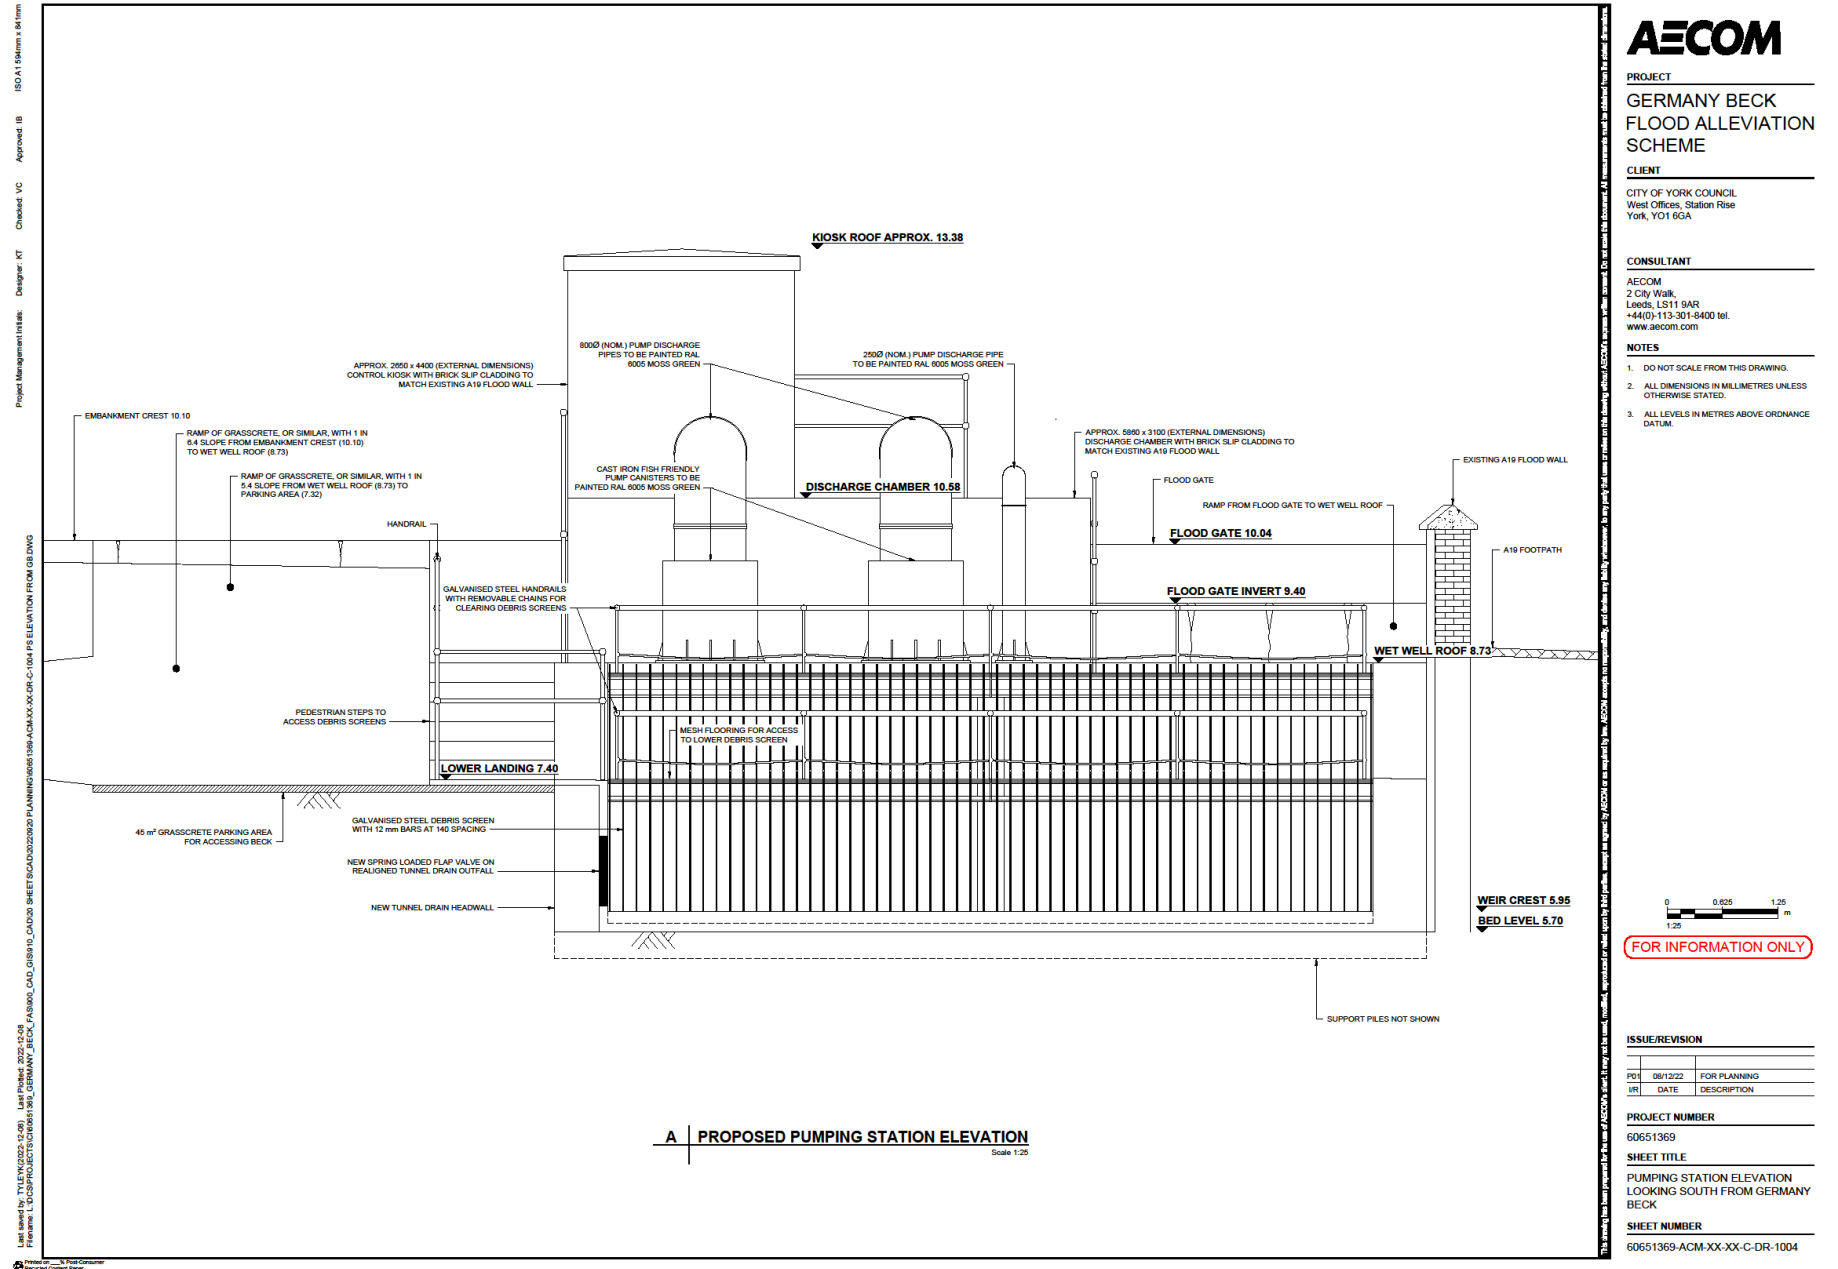

Pumping station elevation From Main Street

ISO A1 184mm x 841mm
 Approved: B
 Checked: VC
 Designer: XT
 Project Management: LK:K:K
 SHEET(S) NO: 60651369-ACM-XX-XX-C-DR-1007 PS ELEVATION FROM A 19 DWG
 Lead: P: 08/12/2022
 Framework: L: 08/12/2022
 Project: 60651369-ACM-XX-XX-C-DR-1007 PS ELEVATION FROM A 19 DWG

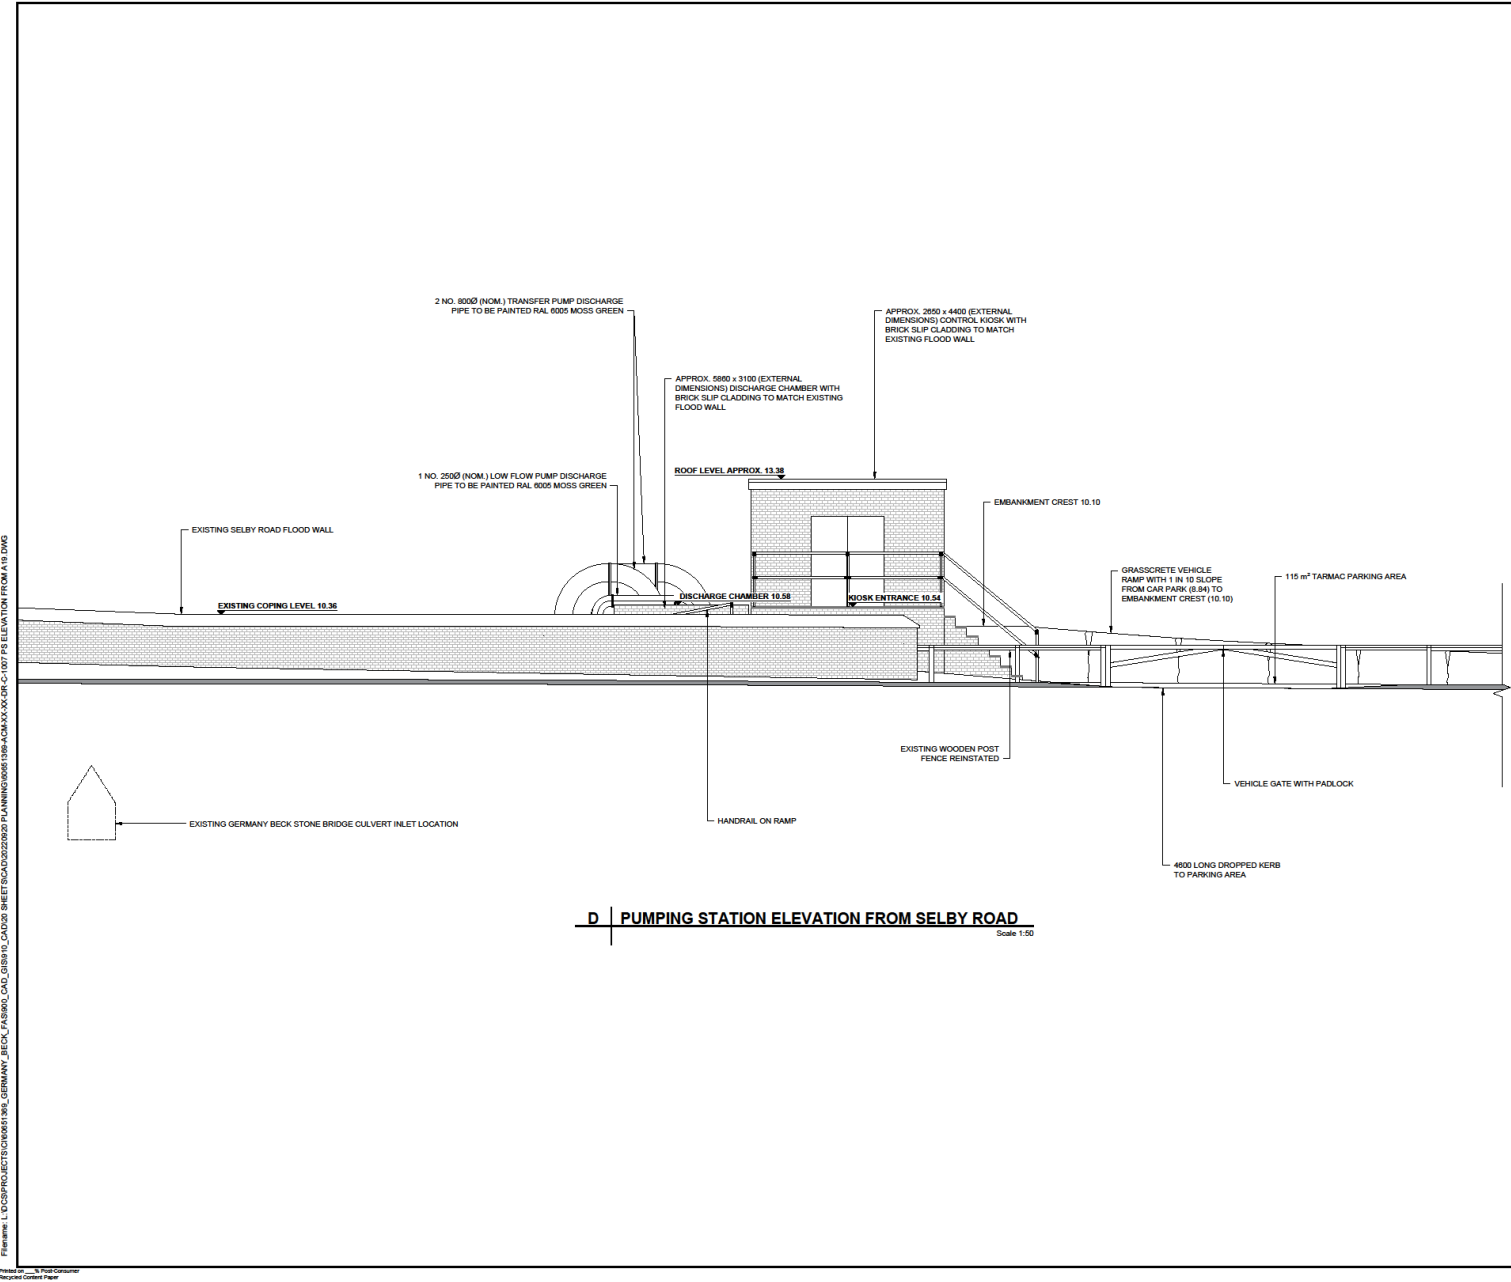

D | PUMPING STATION ELEVATION FROM SELBY ROAD
Scale 1:50

 


PROJECT
GERMANY BECK
FLOOD ALLEVIATION
SCHEME

CLIENT
CITY OF YORK COUNCIL
West Offices, Station Rise
York, YO1 6GA

CONSULTANT
AECOM
2 City Walk,
Leeds, LS11 8AR
+44(0)113-301-8400 tel.
www.aecom.com

- NOTES**
- DO NOT SCALE FROM THIS DRAWING.
 - ALL DIMENSIONS IN MILLIMETRES UNLESS OTHERWISE STATED.
 - ALL LEVELS IN METRES ABOVE ORDNANCE DATUM.



FOR INFORMATION ONLY

ISSUE/REVISION

PI	DATE	DESCRIPTION
PI1	08/12/2022	FOR PLANNING
IR1		


PROJECT NUMBER
60651369

SHEET TITLE
PUMPING STATION ELEVATION
LOOKING EAST FROM SELBY ROAD

SHEET NUMBER
60651369-ACM-XX-XX-C-DR-1007

This drawing has been prepared for the use of AECOM only. It is not to be used for any other purpose without the written consent of AECOM. AECOM accepts no responsibility for the accuracy or completeness of the information provided in this drawing. All measurements shall be taken from the original dimensions.

Pumping station South elevation

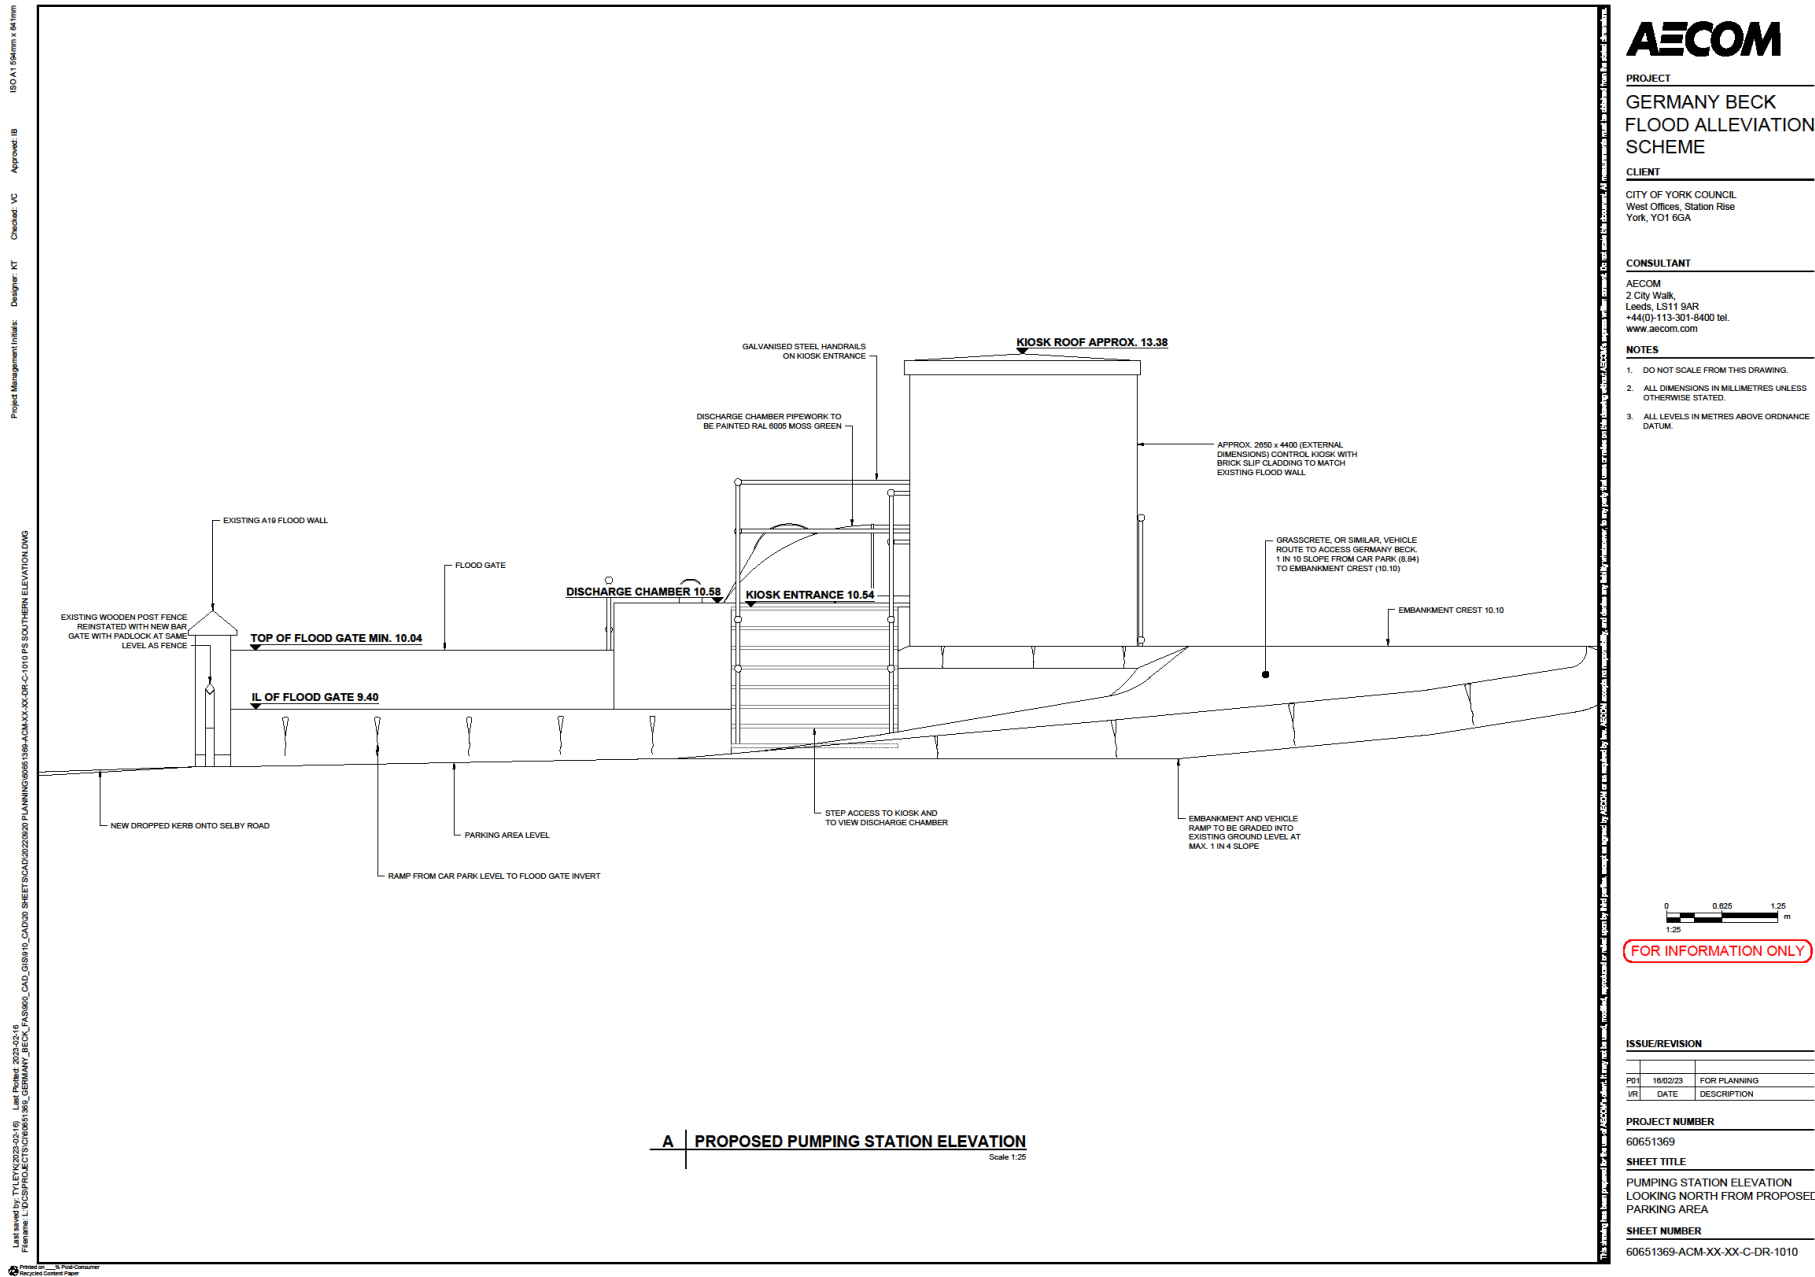

PROJECT
GERMANY BECK FLOOD ALLEVIATION SCHEME


CLIENT
CITY OF YORK COUNCIL
West Offices, Station Rise
York, YO1 6GA

CONSULTANT
AECOM
2 City Walk,
Leeds, LS11 9AR
+44(0)113-301-8400 tel.
www.aecom.com

- NOTES**
- DO NOT SCALE FROM THIS DRAWING.
 - ALL DIMENSIONS IN MILLIMETRES UNLESS OTHERWISE STATED.
 - ALL LEVELS IN METRES ABOVE ORDNANCE DATUM.

Pumping Station section towards Main Street

Project Management Initials: Designer: RT Checked: VC Approved: JB
 ISO A1 50mm x 40mm
 Recycled Content Paper

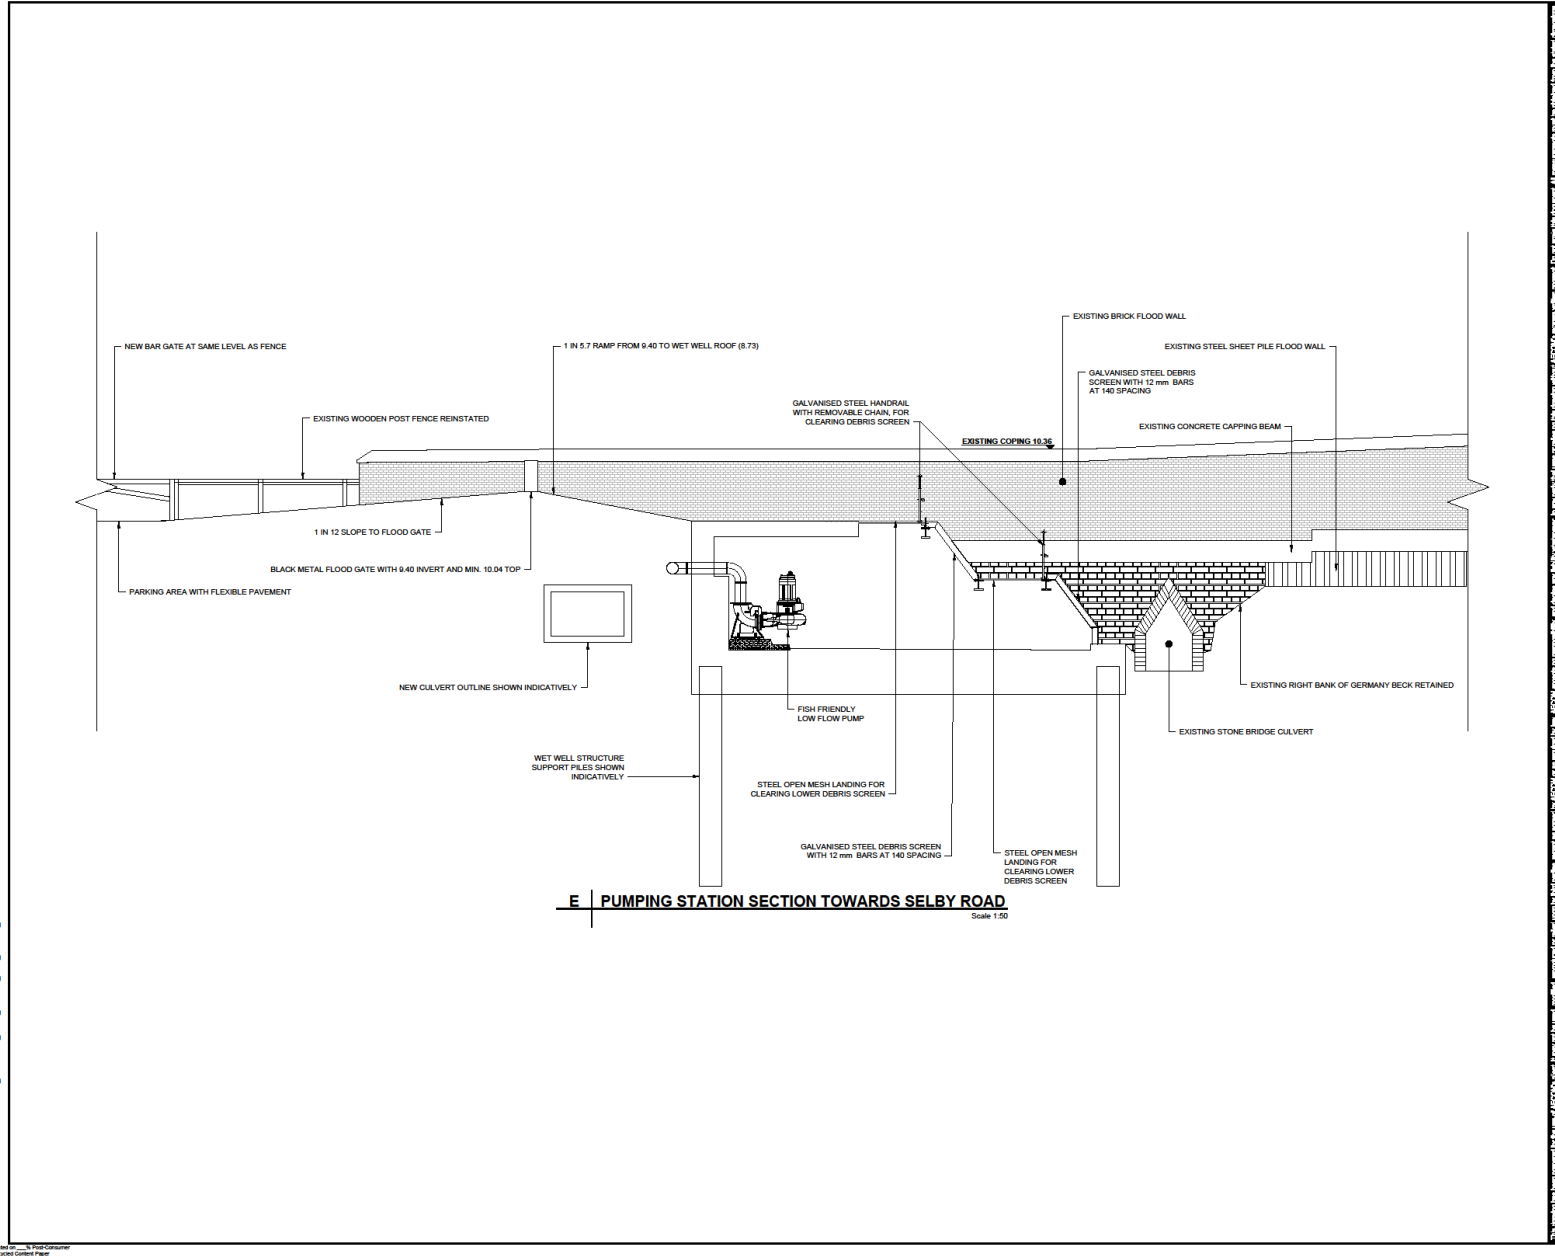

AECOM

PROJECT
 GERMANY BECK
 FLOOD ALLEVIATION
 SCHEME

CLIENT
 CITY OF YORK COUNCIL
 West Offices, Station Rise
 York, YO1 6GA

CONSULTANT
 AECOM
 2 City Walk
 Leeds, LS11 9AR
 +44(0)113-301-8400 tel.
 www.aecom.com

NOTES

- DO NOT SCALE FROM THIS DRAWING.
- ALL DIMENSIONS IN MILLIMETRES UNLESS OTHERWISE STATED.
- ALL LEVELS IN METRES ABOVE ORDNANCE DATUM.

0 1.25 2.5
 1:50

FOR INFORMATION ONLY

ISSUE/REVISION

NO	DATE	FOR PLANNING	DESCRIPTION
01	08/12/2022		


PROJECT NUMBER
60551369

SHEET TITLE
PUMPING STATION SECTION F
LOOKING WEST TOWARDS SELBY
ROAD

SHEET NUMBER
60551369-ACM-XX-XX-C-DR-1008

Pumping station section towards playing field

ISO A1 594mm x 841mm
 Approved: IB
 Checked: VC
 Designer: KT
 Project Management Initials:
 L:\1\2023\12\021 - User Profiles - 2023-12-08
 Filename: L:\CDS\PROJECTS\061951369_GERMANY_BECK_FLOOD_ALLEVIATION_SHEETS\ACAD\2023\20231208\061951369-ACM-XX-XX-C-DR-1009-PS SECTION TOWARDS PLAYING FIELD.dwg

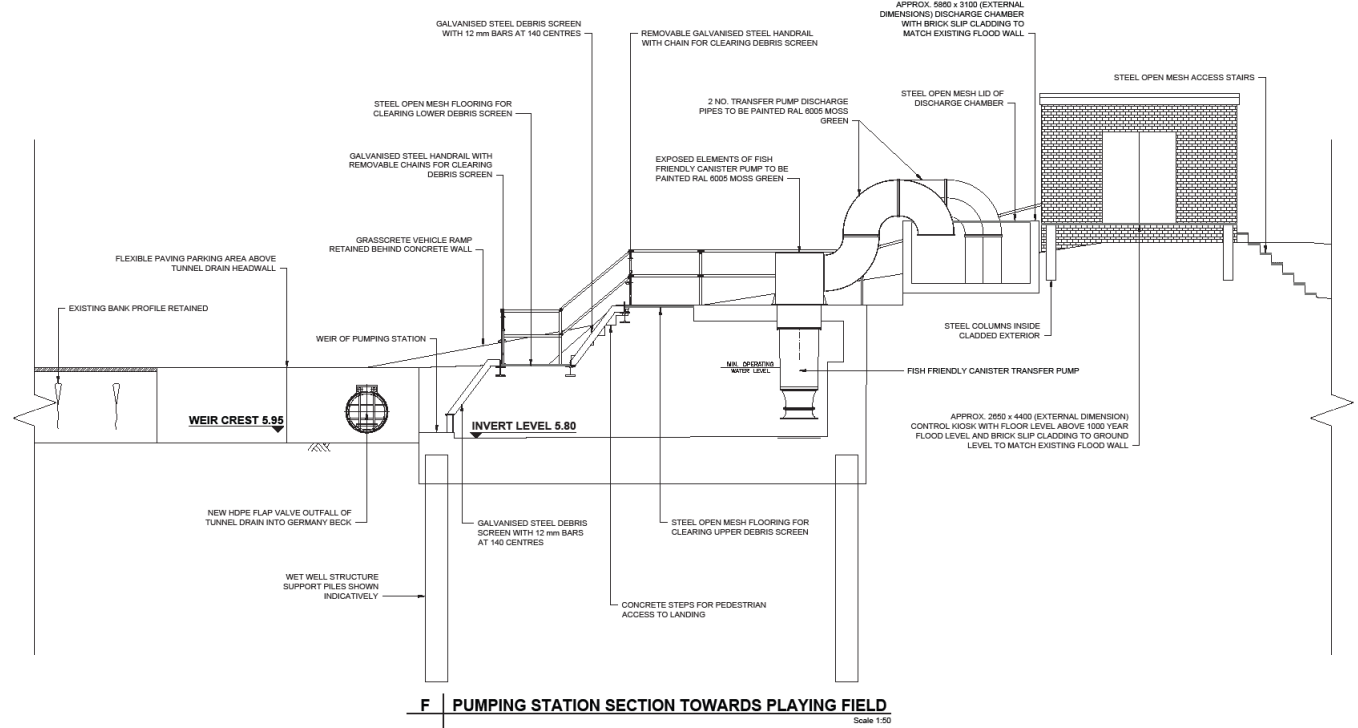


PROJECT
**GERMANY BECK
 FLOOD ALLEVIATION
 SCHEME**

CLIENT
 CITY OF YORK COUNCIL
 West Offices, Station Rise
 York, YO1 6GA

CONSULTANT
 AECOM
 2 City Walk
 Leeds, LS11 5AR
 +44(0)113-301-8400 tel.
 www.aecom.com

 - NOTES**
- DO NOT SCALE FROM THIS DRAWING.
 - ALL DIMENSIONS IN MILLIMETRES UNLESS OTHERWISE STATED.
 - ALL LEVELS IN METRES ABOVE ORDNANCE DATUM.



FOR INFORMATION ONLY

ISSUE/REVISION

NO	DATE	DESCRIPTION
P01	08/12/2022	FOR PLANNING

PROJECT NUMBER
 60651369


SHEET TITLE
 PUMPING STATION SECTION F
 LOOKING EAST TOWARDS FIELD

SHEET NUMBER
 60651369-ACM-XX-XX-C-DR-1009

Outfall elevation (west side of Main Street)


ISO A1 584mm x 841mm
Approved: IB
Designer: KT
Check: VC
Project Management Initials:

GERMANY BECK FLOOD ALLEVIATION SCHEME
C-DR-1006 OUTFALL ELEVATION DWG
Last saved by: TYLEY, N (2022, 12-02) Last Printed: 2022-12-09
Filename: L:\DCS\PROJECTS\060661366_GERMANY_BECK_FACTS\900_CAD_09\19_0_CAD_09_SHEET\060661366_PLANNING\6061366_ACM-XX-XX-C-DR-1006_OUTFALL ELEVATION.DWG

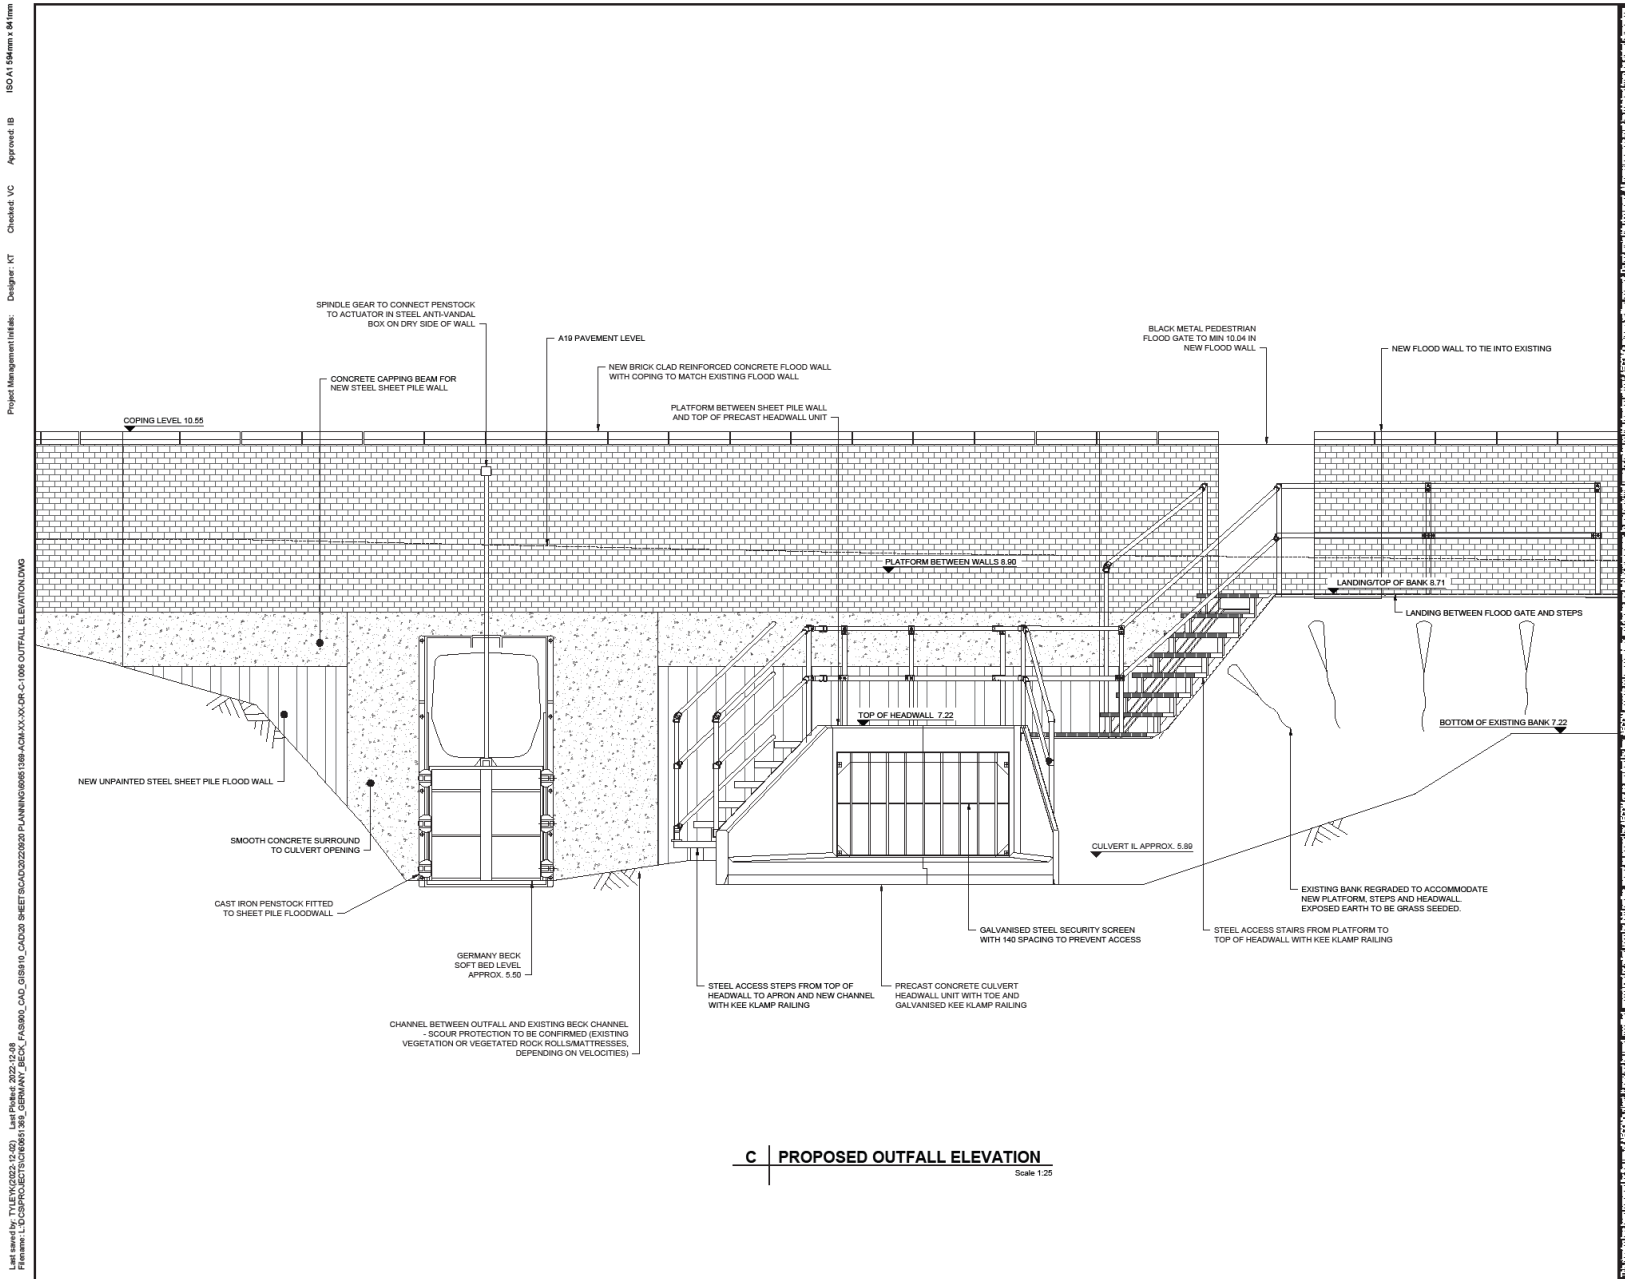

C | PROPOSED OUTFALL ELEVATION

 Scale 1:25



FOR INFORMATION ONLY

ISSUE/REVISION

NO.	DATE	DESCRIPTION
01	08/12/22	FOR PLANNING

PROJECT NUMBER

60651369

SHEET TITLE

OUTFALL ELEVATION

SHEET NUMBER


60651369-ACM-XX-XX-C-DR-1006



Landing Lane embankment

Project Management (M/Ref): Designer: KT Check: VC Approved: IB ISO A1 594mm x 841mm

Last saved by: TYLEY(2023:12:08) Last Printed: 2023:12:08
 Filename: L:\DC2\PROJECTS\016051369_GENERAL_ARRANGEMENTS\016051369_GENERAL_ARRANGEMENTS.DWG

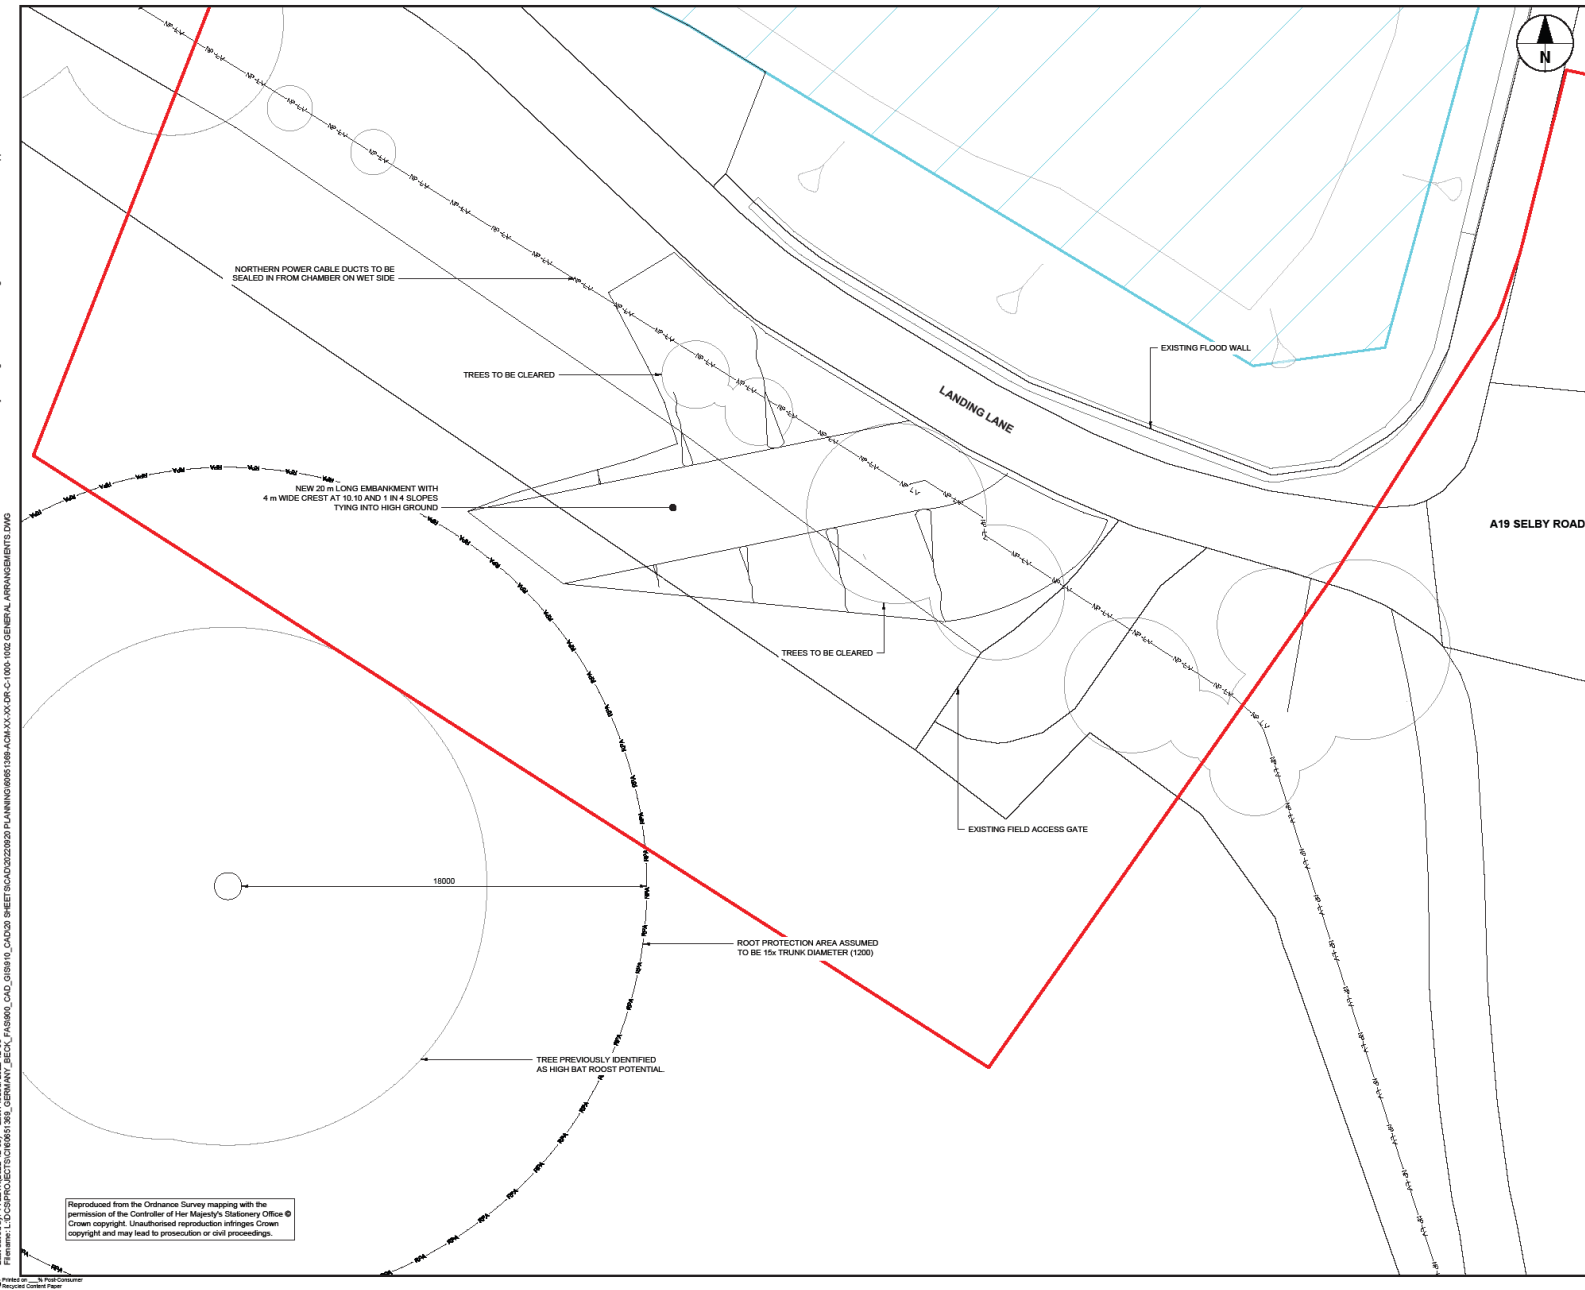

Reproduced from the Ordnance Survey mapping with the permission of the Controller of Her Majesty's Stationery Office. Crown copyright. Unauthorised reproduction infringes Crown copyright and may lead to prosecution or civil proceedings.



PROJECT
 GERMANY BECK
 FLOOD ALLEVIATION
 SCHEME

CLIENT
 CITY OF YORK COUNCIL
 West Offices, Station Rise
 York, YO1 6GA

CONSULTANT
 AECOM
 2 City Walk,
 Leeds, LS11 6AR
 +44(0)-113-301-8400 tel.
 www.aecom.com

- NOTES**
- DO NOT SCALE FROM THIS DRAWING.
 - ALL DIMENSIONS IN MILLIMETRES UNLESS OTHERWISE STATED.
 - ALL LEVELS IN METRES ABOVE ORDNANCE DATUM.
 - THE FLOOD DEFENCE LEVEL OF 10.04 HAS BEEN CALCULATED FROM THE OUSE WASHLANDS MODEL 100 YEAR + 2.4% CLIMATE CHANGE ALLOWANCE FLOOD LEVEL OF 9.82 WITH 0.22 OF UNCERTAINTY.

LEGEND

- SITE BOUNDARY
- SITE OF SPECIAL SCIENTIFIC INTEREST



FOR INFORMATION ONLY

ISSUE/REVISION

NO	DATE	DESCRIPTION
01	02/12/2022	FOR PLANNING

PROJECT NUMBER

60651369

SHEET TITLE

GENERAL ARRANGEMENT
 LANDING LANE EMBANKMENT

SHEET NUMBER

60651369-ACM-XX-XX-DR-C-1002