


SECOND FLOOR

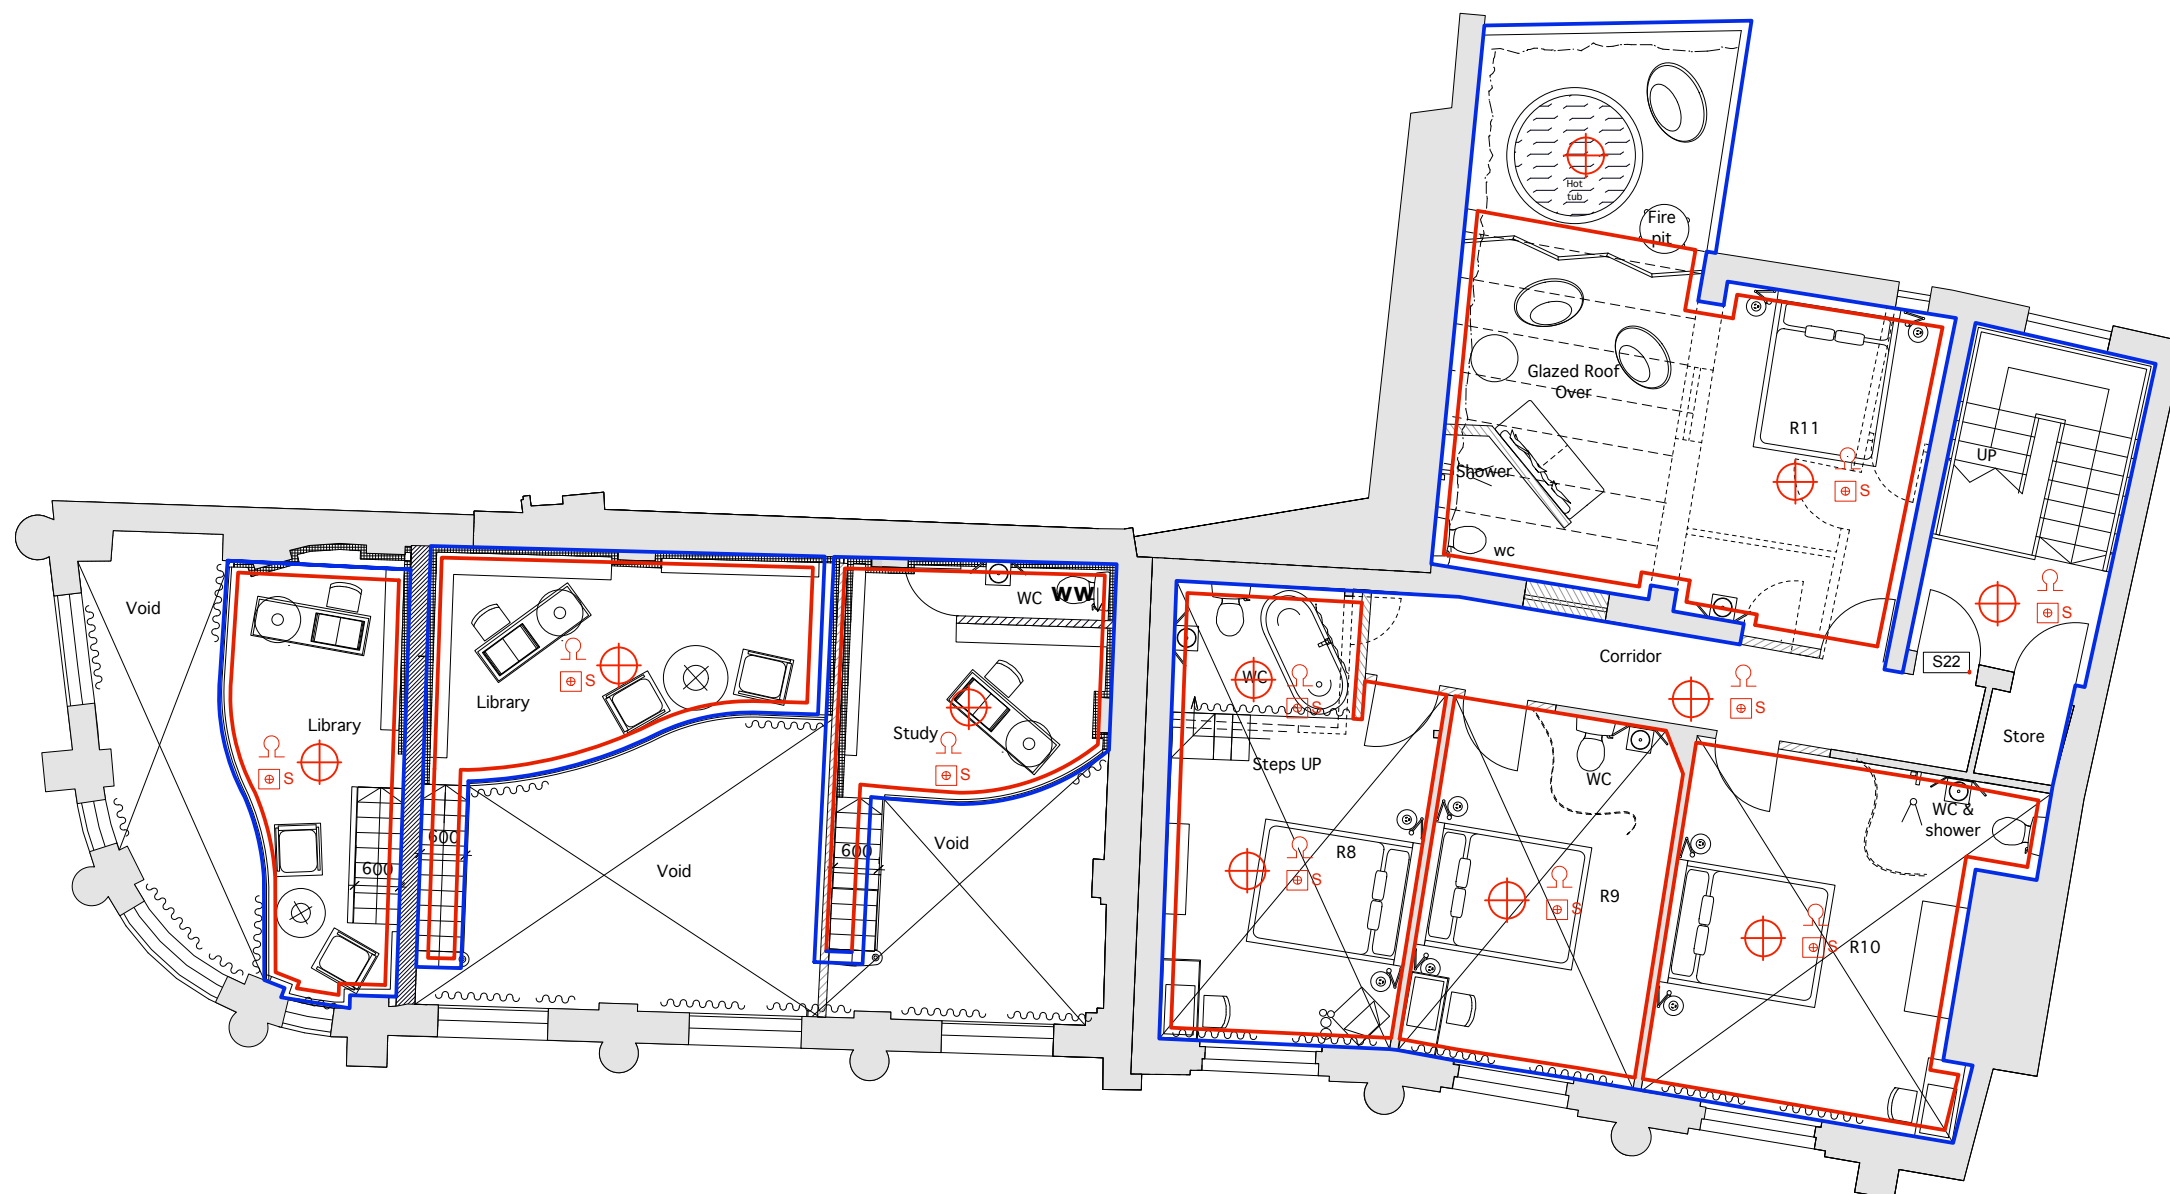

SECOND FLOOR PLAN



LICENSING SYMBOLS

	Visual Warning Detector		Water Fire Extinguisher		Fire Notice
	Smoke Detector		Carbon Dioxide Fire Extinguisher		Vision Panel 30mins Fire Glass
	Heat Detector		Foam Fire Extinguisher		Emergency Lights
	Illuminated 'EMERGENCY EXIT' Sign (Directional when prefixed with AD)		Dry Powder Fire Extinguisher		Disabled Alarm Call Point
	Fire Alarm Sounder		Fire Blanket		CCTV
	Emergency Break Glass Call Point		PANIC		Door Fitted With Panic Ironmongery

LICENSING ZONES KEY:

	LICENSED AREA
	DEMISE OF UNIT TO BE OCCUPIED.

JULIAN
JULIAN TAYLOR DESIGN ASSOCIATES


Project: IMPOSSIBLE (YORK)
Client: Tokyo Industries
Drawing Title: 2nd floor - Licensing plan
Drawing Number: 571/P/025
Scale: 1:50@A1
Revision: -
Drawn by: -
Checked by: -

Revision	Date	Comments

The Best One Here 28 Wharfedale Road Dewsbury WF15 8AA
Tel: 01924 512221 Fax: 01924 512222
Email: julian@jtd.co.uk www.jtd.co.uk

This drawing is the copyright of J.T.D. and cannot be copied, used or reproduced without express written permission.
All dimensions to be checked on site, do not scale from this drawing.

FIRST FLOOR

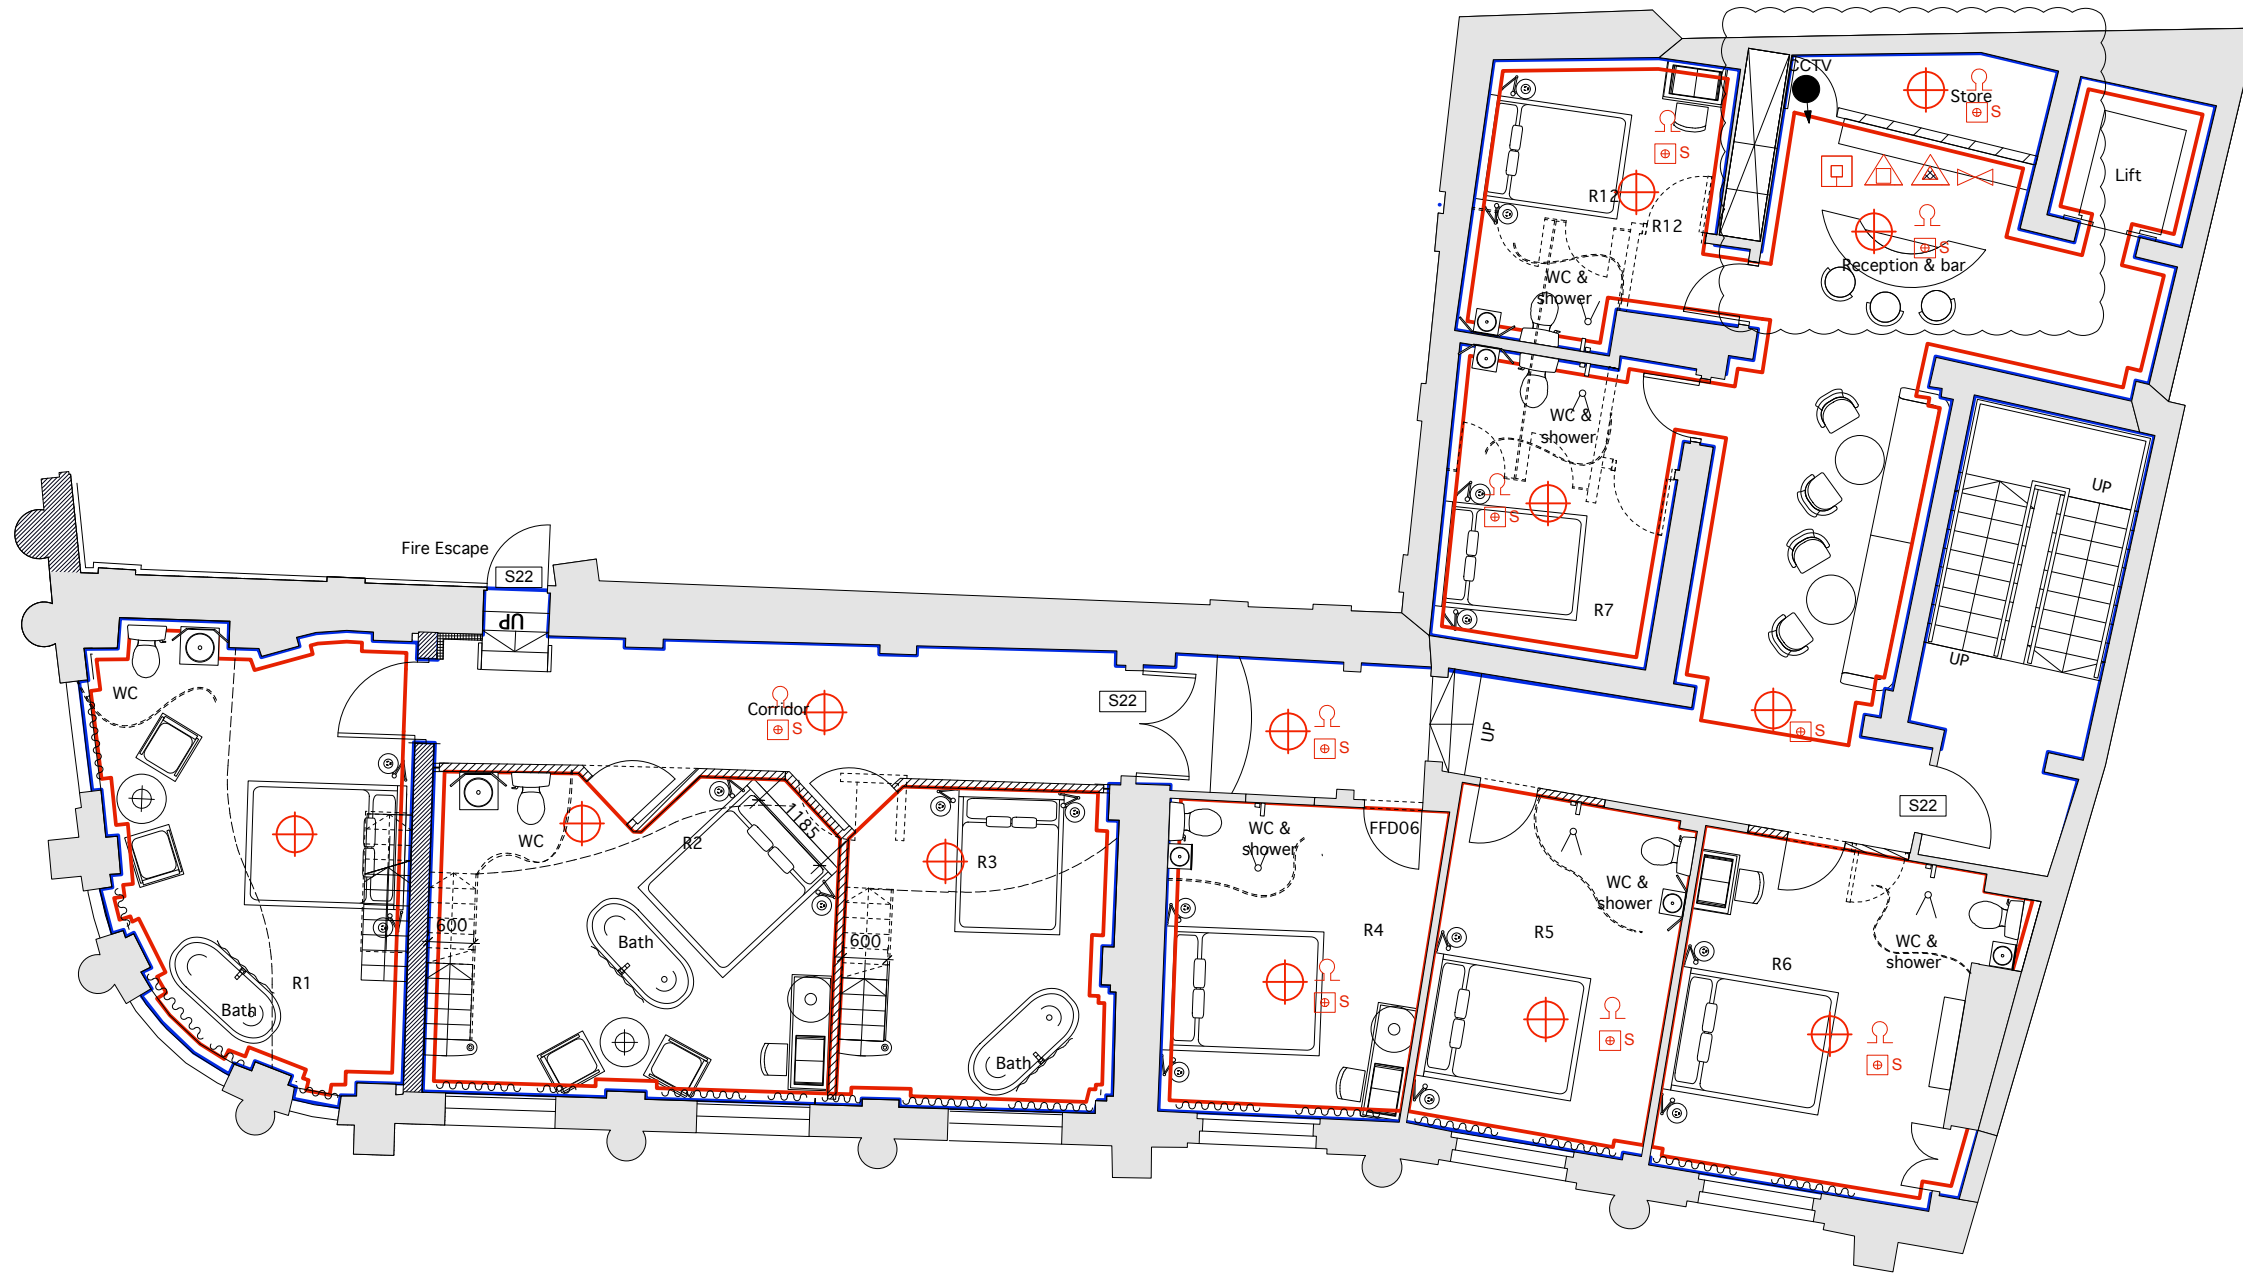

FIRST FLOOR PLAN



LICENSING SYMBOLS

	Visual Warning Detector		Water Fire Extinguisher		Fire Notice
	Smoke Detector		Carbon Dioxide Fire Extinguisher		Vision Panel 30mins Fire Glass
	Heat Detector		Foam Fire Extinguisher		Emergency Lights
	Illuminated 'EMERGENCY EXIT' Sign (Directional when prefixed with AD)		Dry Powder Fire Extinguisher		Disabled Alarm Call Point
	Fire Alarm Sounder		Fire Blanket		CCTV
	Emergency Break Glass Call Point		PANIC		
			Door Fitted With Panic Ironmongery		

LICENSING ZONES KEY:

	LICENSED AREA
	DEMISE OF UNIT TO BE OCCUPIED.


JULIAN
JULIAN TAYLOR DESIGN ASSOCIATES

Project: IMPOSSIBLE (YORK)
Client: Tokyo Industries
Drawing Title: 1st floor - Licensing plan
Drawing Number: 571/P/026
Scale: 1:50@A1
Revision: -
Drawn by: -
Checked by: -
Approved by: -

Revision	Date	Comments

The Best Check Here 28 Whitaker Road Bury 2011 004
Tel: 0161 512311 Fax: 0161 512312
Email: info@juliantaylor.co.uk
This drawing is the copyright of J.T.A. and cannot be copied, used or reproduced without express written permission.
All dimensions to be checked on site. Do not scale from this drawing.

GROUND FLOOR

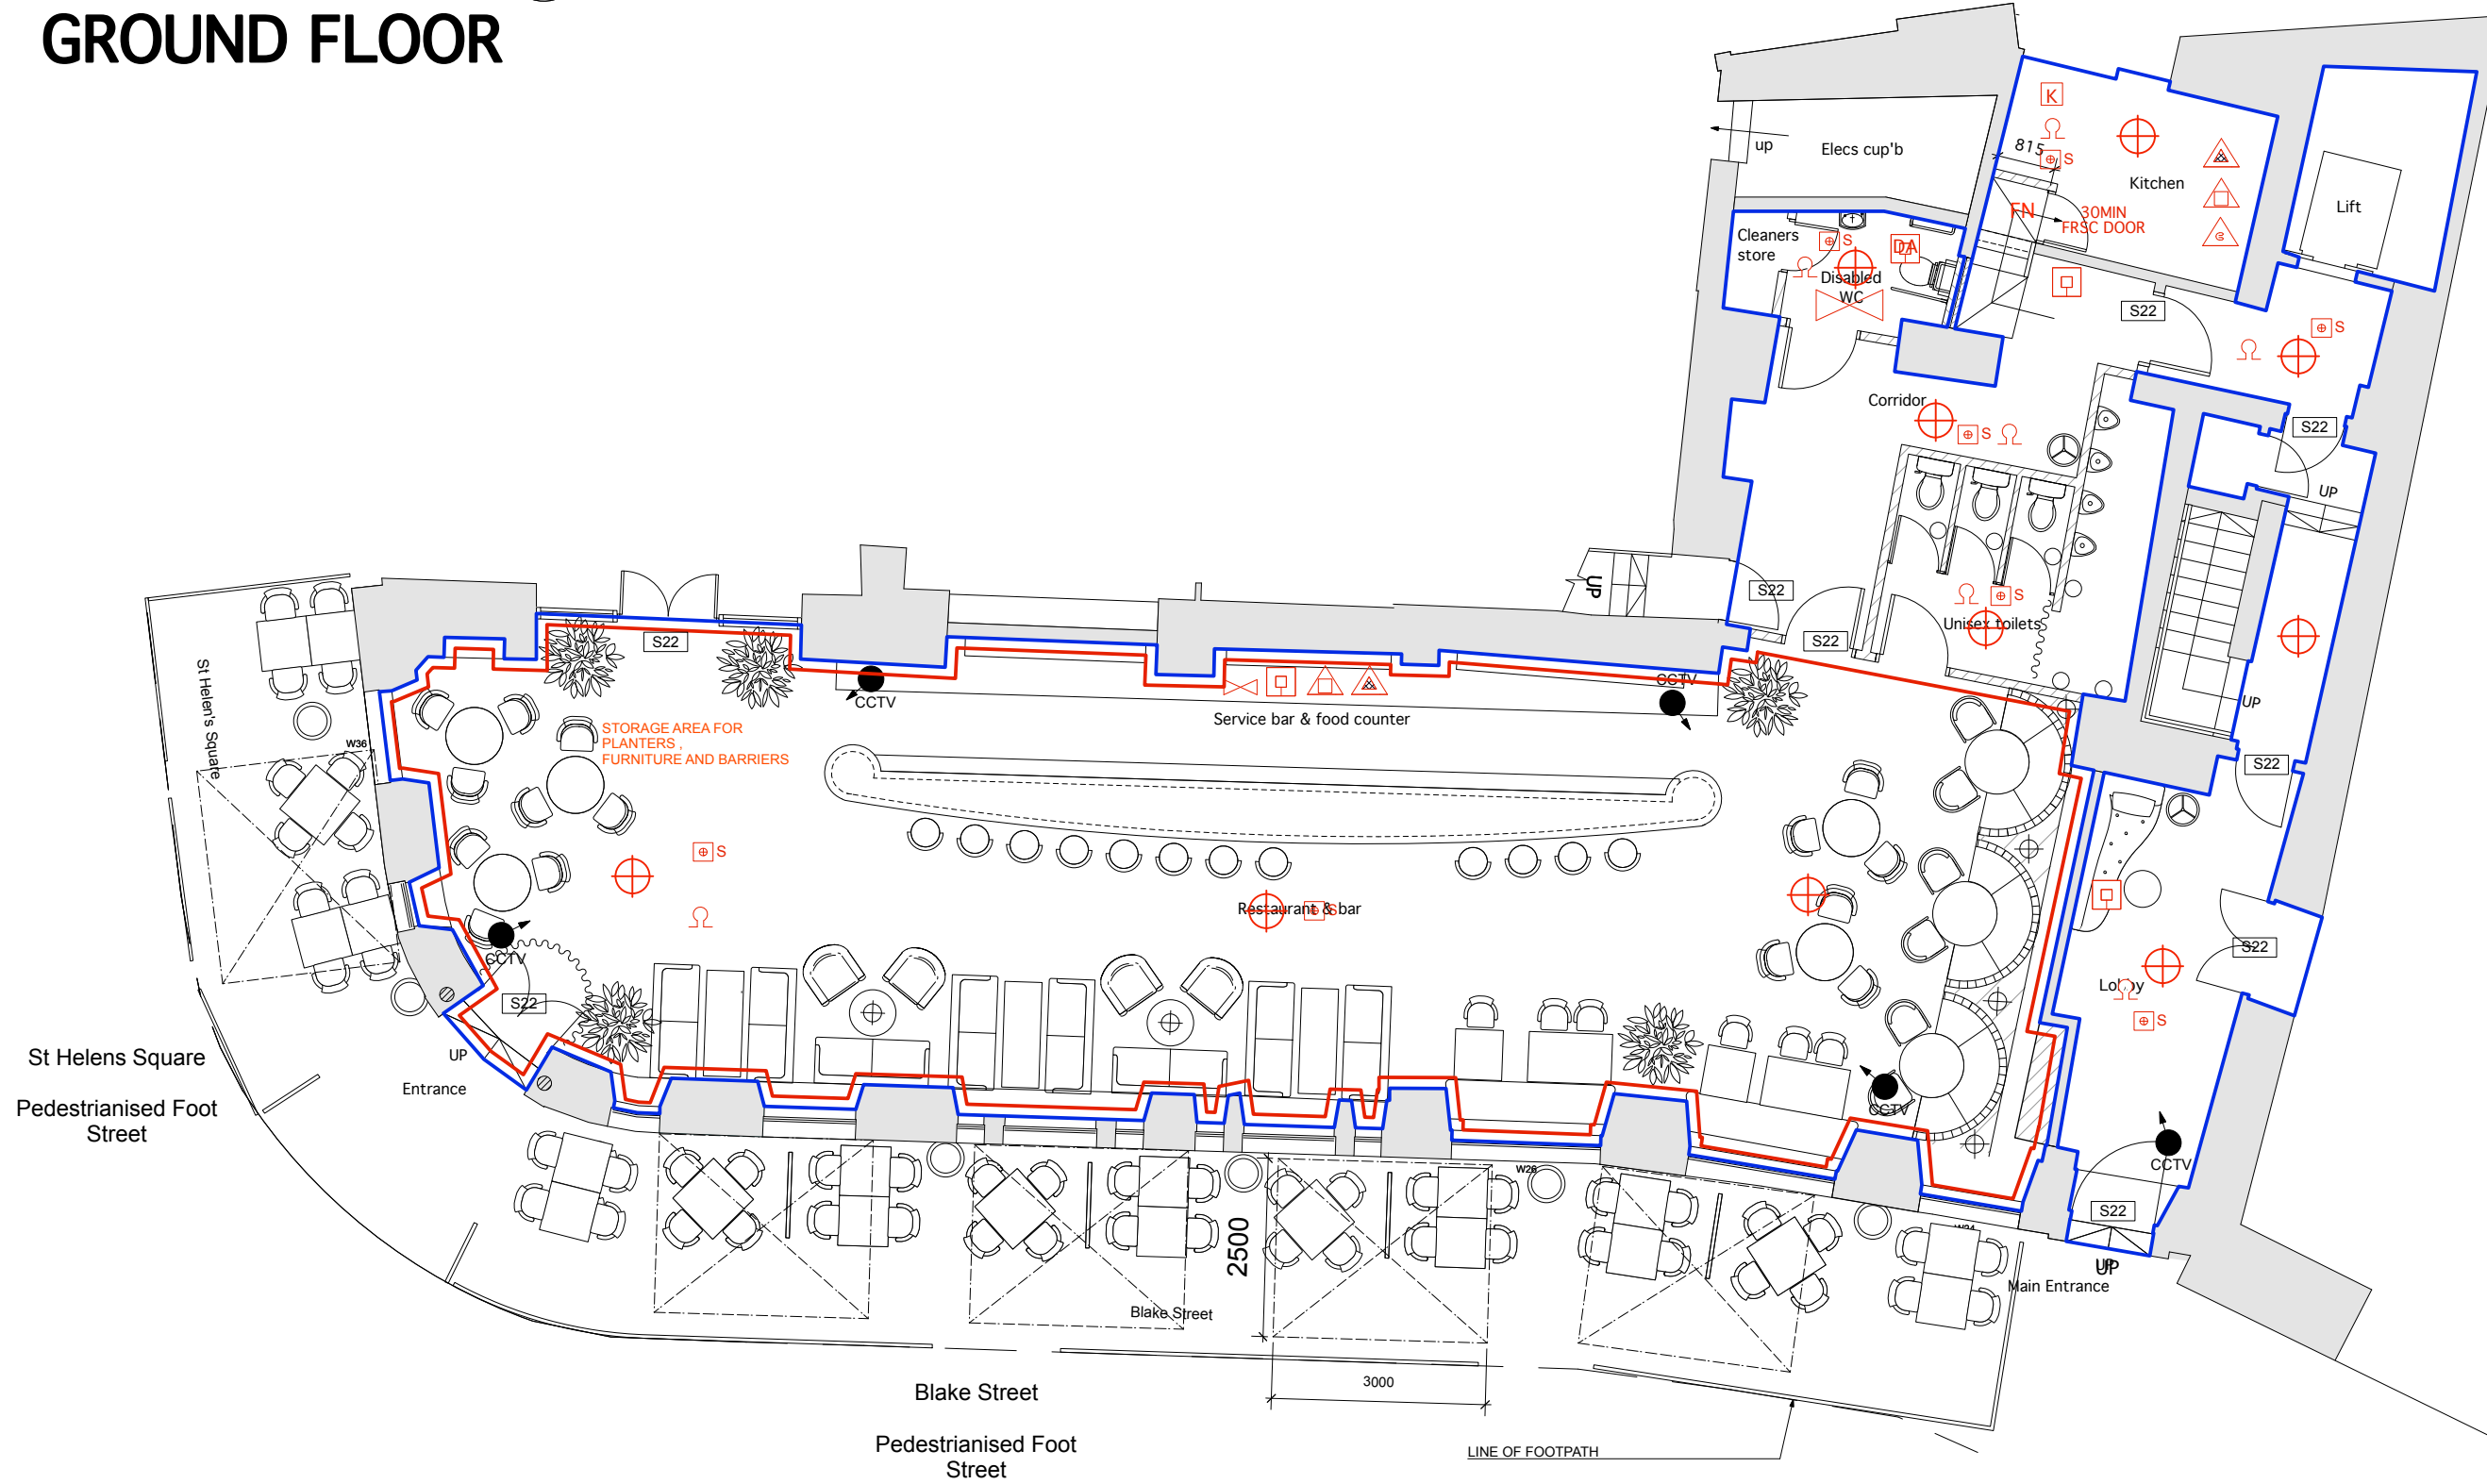


LICENSING SYMBOLS

	Visual Warning Detector		Water Fire Extinguisher		Fire Notice
	Smoke Detector		Carbon Dioxide Fire Extinguisher		Vision Panel 30mins Fire Glass
	Heat Detector		Foam Fire Extinguisher		Emergency Lights
	Illuminated 'EMERGENCY EXIT' Sign (Directional when prefixed with AD)		Dry Powder Fire Extinguisher		Disabled Alarm Call Point
	Fire Alarm Sounder		Fire Blanket		CCTV
	Emergency Break Glass Call Point		Door Fitted With Panic Ironmongery		

LICENSING ZONES KEY:

	LICENSED AREA
	DEMISE OF UNIT TO BE OCCUPIED.

 GROUND FLOOR PLAN




JULIAN

JULIAN TAYLOR DESIGN ASSOCIATES


Project:	IMPOSSIBLE (YORK)
Client:	Tokyo Industries
Drawing Title:	Ground floor - Licensing Plan
Drawing Number:	571/P/027
Scale:	1:50@A1
Revision:	-
Drawn by:	
Checked by:	
Approved by:	
Date:	
Comments:	

This drawing is the copyright of Julian Taylor and cannot be copied, used or reproduced without express written permission. All dimensions to be checked on site. Do not scale from this drawing.

IMPOSSIBLE (YORK)
571/P/027
BASEMENT

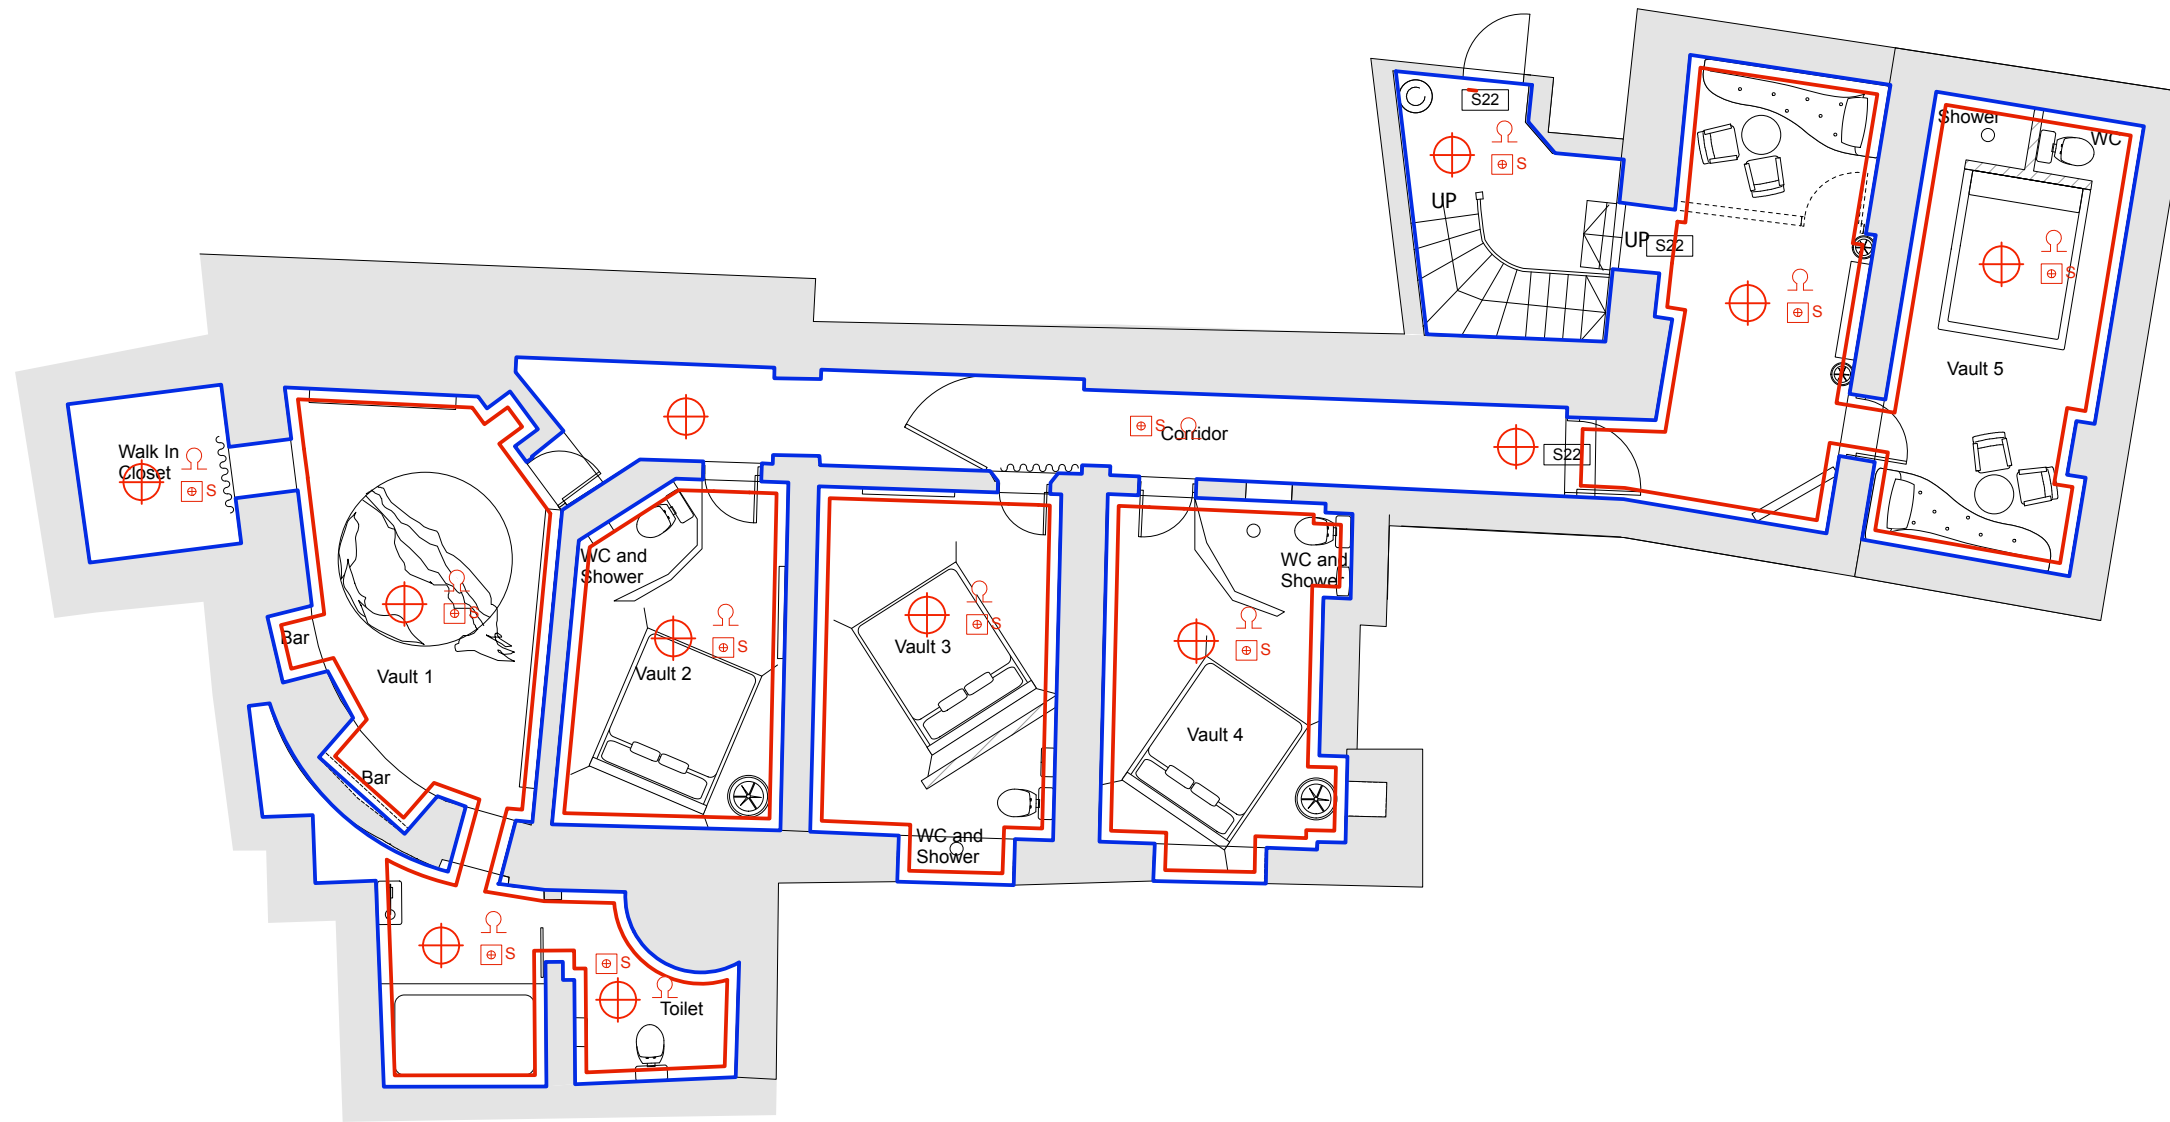

BASEMENT PLAN

 

LICENSING SYMBOLS

	Visual Warning Detector		Water Fire Extinguisher		FN Fire Notice
	Smoke Detector		Carbon Dioxide Fire Extinguisher		VP Vision Panel 30mins Fire Glass
	Heat Detector		Foam Fire Extinguisher		Emergency Lights
	Illuminated 'EMERGENCY EXIT' Sign (Directional when prefixed with AD)		Dry Powder Fire Extinguisher		Disabled Alarm Call Point
	Fire Alarm Sounder		Fire Blanket		CCTV
	Emergency Break Glass Call Point		PANIC Door Fitted With Panic Ironmongery		

LICENSING ZONES KEY:

	LICENSED AREA
	DEMISE OF UNIT TO BE OCCUPIED.

JULIAN
JULIAN TAYLOR DESIGN ASSOCIATES

Project: IMPOSSIBLE (YORK)
Client: Tokyo Industries
Drawing Title: Basement - Licensing Plan
Drawing Number: 571/P/027
Scale:
Revision:
Drawn by:
Checked by:
Approved by:

Revision	Date	Comments

The Best Check Here 28 Waterloo Road Bury 911 8AA
Tel: 0161 251211 Fax: 0161 251212
Email: info@julian.co.uk
This drawing is the copyright of Julian Taylor and cannot be copied, used or reproduced without express written permission.
All dimensions to be checked on site, do not scale from this drawing.