




## Planning B Committee

23/00283/FUL

Fulford Flood Alleviation Scheme Fulford Ings and Playing Fields

ISO A1 (841mm x 594mm) Approved: JB Checked: VC Designer: KT Project Management Initials: Project Management Initials: DRG. 60651369-ACM-XX-XX-DR-C-1000 GENERAL ARRANGEMENTS DWG

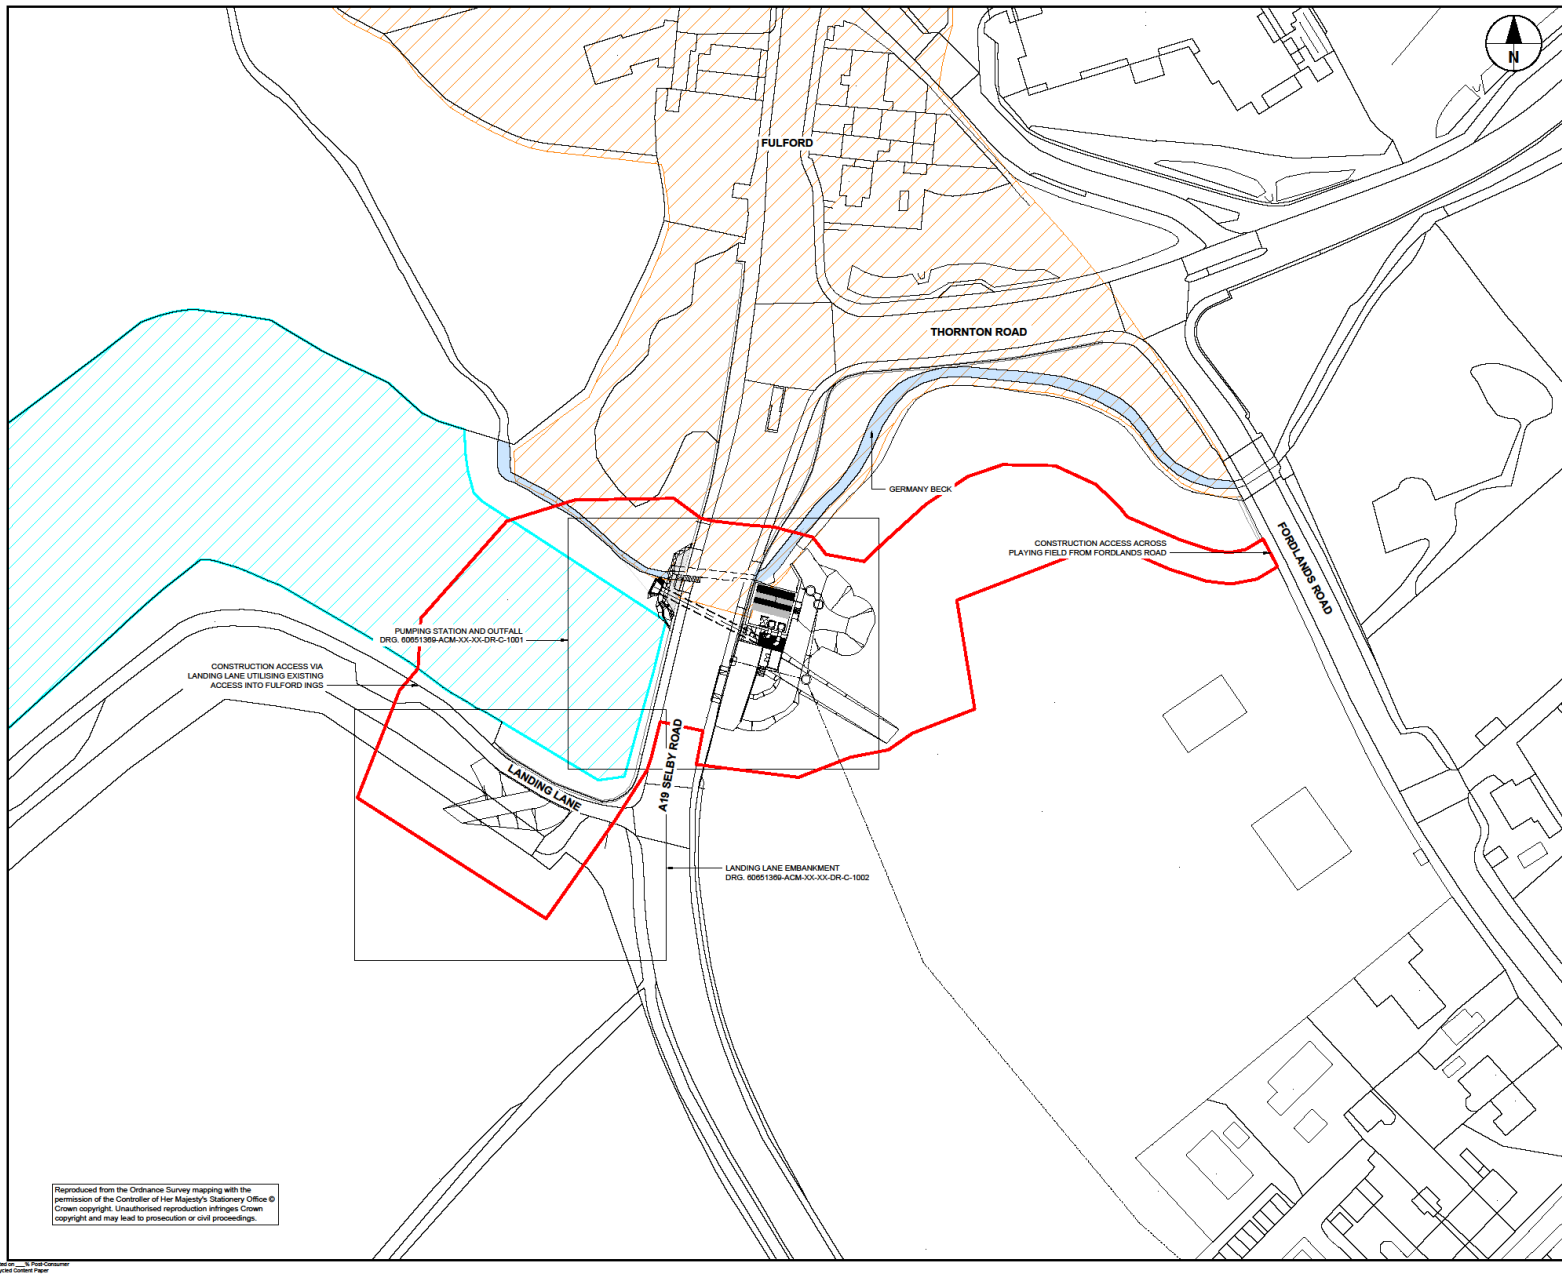

Reproduced from the Ordnance Survey mapping with the permission of the Controller of Her Majesty's Stationary Office © Crown copyright. Unauthorised reproduction infringes Crown copyright and may lead to prosecution or civil proceedings.



**PROJECT**  
 GERMANY BECK  
 FLOOD ALLEVIATION  
 SCHEME

**CLIENT**  
 CITY OF YORK COUNCIL  
 West Offices, Station Rise  
 York, YO1 6GA

**CONSULTANT**  
 AECOM  
 2 City Walk,  
 Leeds, LS11 9AR  
 +44(0)-113-301-8400 tel.  
 www.aecom.com

- NOTES**
- DO NOT SCALE FROM THIS DRAWING.
  - ALL DIMENSIONS IN MILLIMETRES UNLESS OTHERWISE STATED.
  - ALL LEVELS IN METRES ABOVE ORDNANCE DATUM.
  - THE FLOOD DEFENCE LEVEL OF 10.04 HAS BEEN CALCULATED FROM THE OUSE WASHLANDS MODEL 100 YEAR + 2.4 % CLIMATE CHANGE ALL OUNAGE FLOOD LEVEL OF 8.82 WITH 0.2% OF UNCERTAINTY.

- LEGEND**
- SITE BOUNDARY
  - ▨ CONSERVATION AREA
  - ▨ SITE OF SPECIAL SCIENTIFIC INTEREST



FOR INFORMATION ONLY

**ISSUE/REVISION**


NO	DATE	DESCRIPTION
PO1	02/12/2022	FOR PLANNING

**PROJECT NUMBER**  
 60651369

**SHEET TITLE**  
 GENERAL ARRANGEMENT  
 SITE PLAN

**SHEET NUMBER**  
 60651369-ACM-XX-XX-DR-C-1000

# General site arrangement

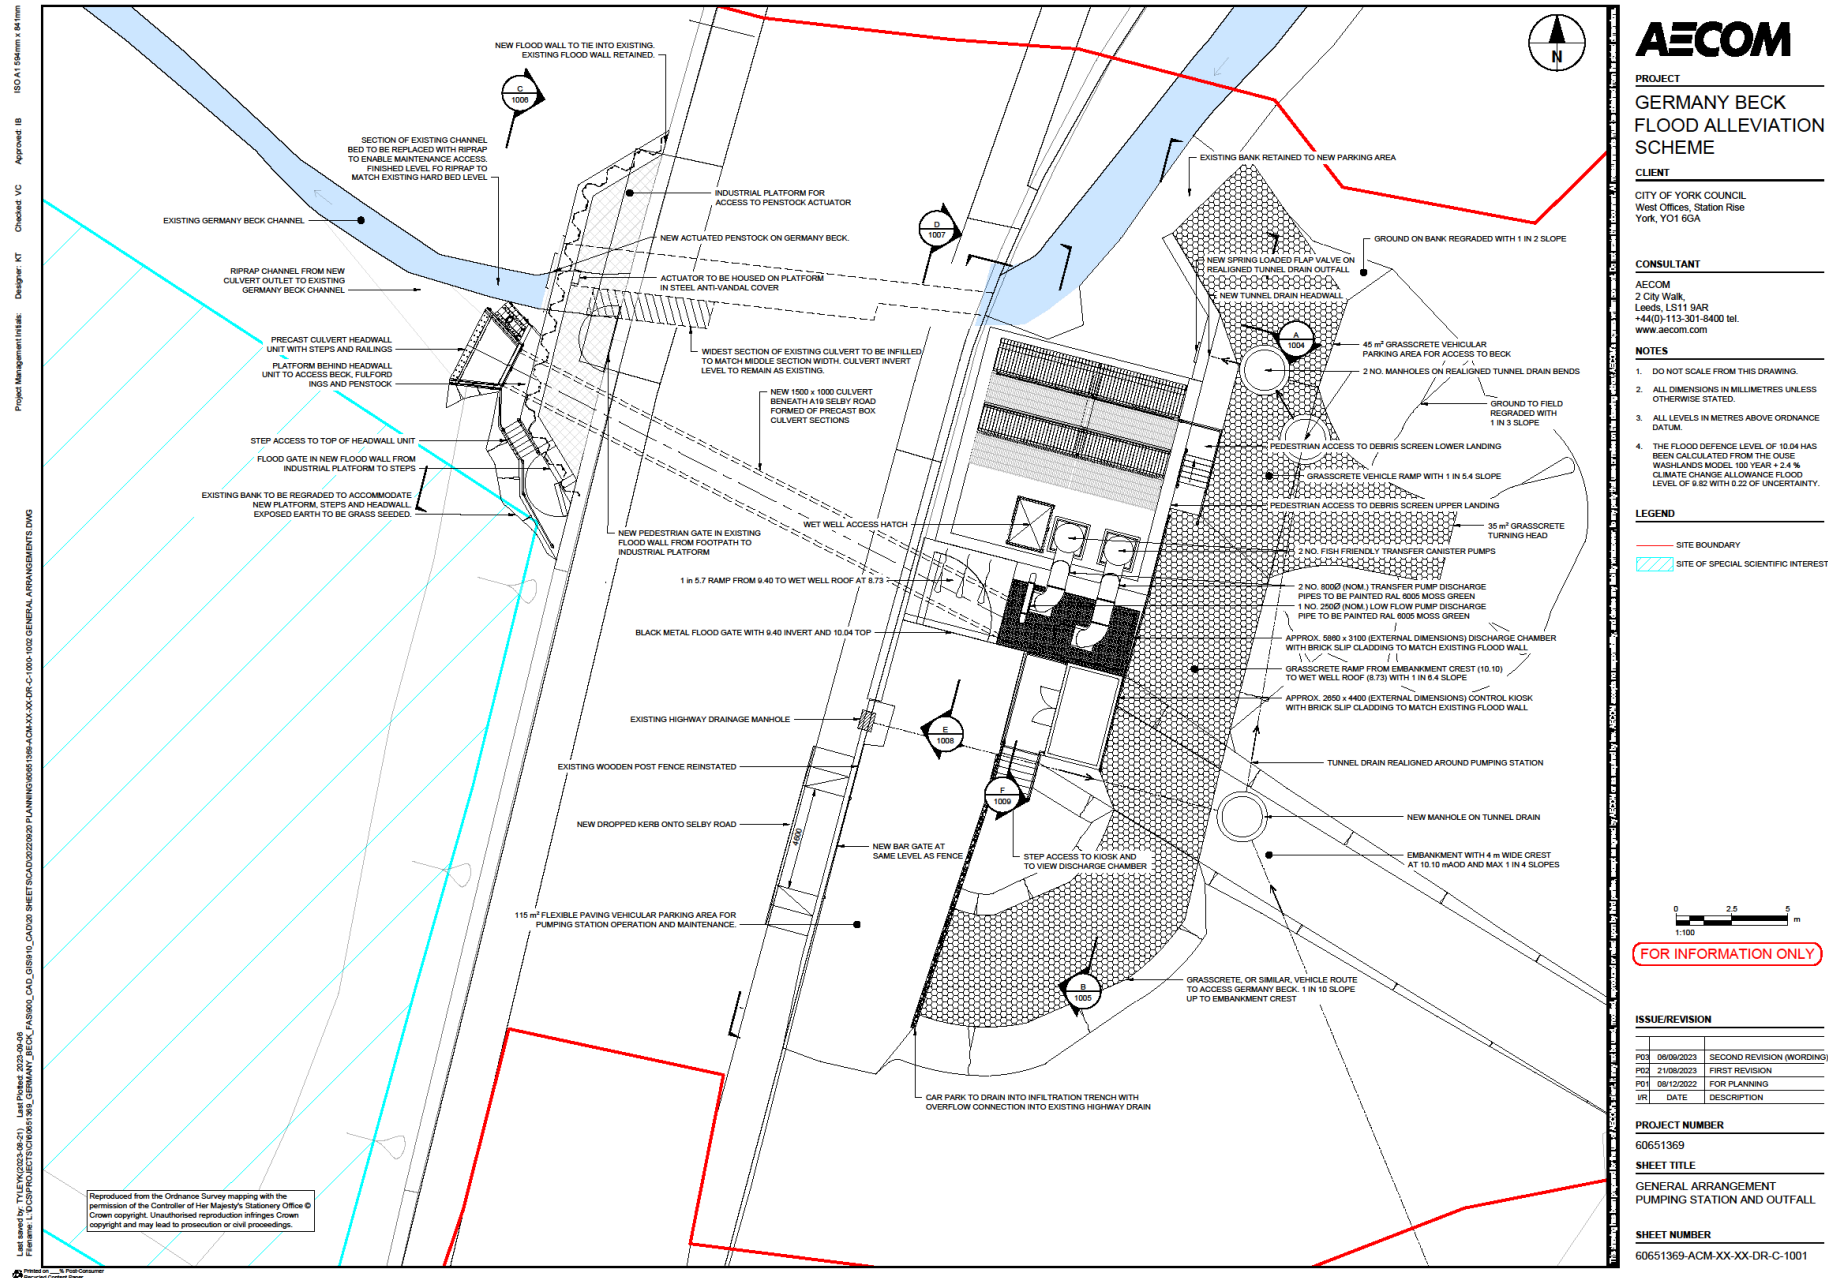

**PROJECT**  
GERMANY BECK FLOOD ALLEVIATION SCHEME

**CLIENT**  
CITY OF YORK COUNCIL  
West Offices, Station Rise  
York, YO1 6GA

**CONSULTANT**  
AECOM  
2 City Walk,  
Leeds, LS11 6AR  
+44(0)-113-301-8400 tel.  
www.aecom.com

**NOTES**

- DO NOT SCALE FROM THIS DRAWING.
- ALL DIMENSIONS IN MILLIMETRES UNLESS OTHERWISE STATED.
- ALL LEVELS IN METRES ABOVE ORDNANCE DATUM.
- THE FLOOD DEFENCE LEVEL OF 10.04 HAS BEEN CALCULATED FROM THE OUSE WASHLANDS MODEL, 100 YEAR + 24% CLIMATE CHANGE ALLOWANCE FLOOD LEVEL OF 9.82 WITH 0.22 OF UNCERTAINTY.

**LEGEND**

- SITE BOUNDARY
- SITE OF SPECIAL SCIENTIFIC INTEREST

**ISSUE/REVISION**

NO	DATE	DESCRIPTION
PO1	09/06/2023	SECOND REVISION (WORDING)
PO2	21/08/2023	FIRST REVISION
PO1	09/12/2022	FOR PLANNING
VR		

**PROJECT NUMBER**  
60651369


**SHEET TITLE**  
GENERAL ARRANGEMENT PUMPING STATION AND OUTFALL

**SHEET NUMBER**  
60651369-ACM-XX-DR-C-1001


**FOR INFORMATION ONLY**

BSA AT 1516mm x A4 trim Approved IB Checked VC Designer KT Project Management Initials: Designer KT  
 BSA AT 1516mm x A4 trim Approved IB Checked VC Designer KT Project Management Initials: Designer KT  
 BSA AT 1516mm x A4 trim Approved IB Checked VC Designer KT Project Management Initials: Designer KT

# Pumping station elevations from East (playing field)

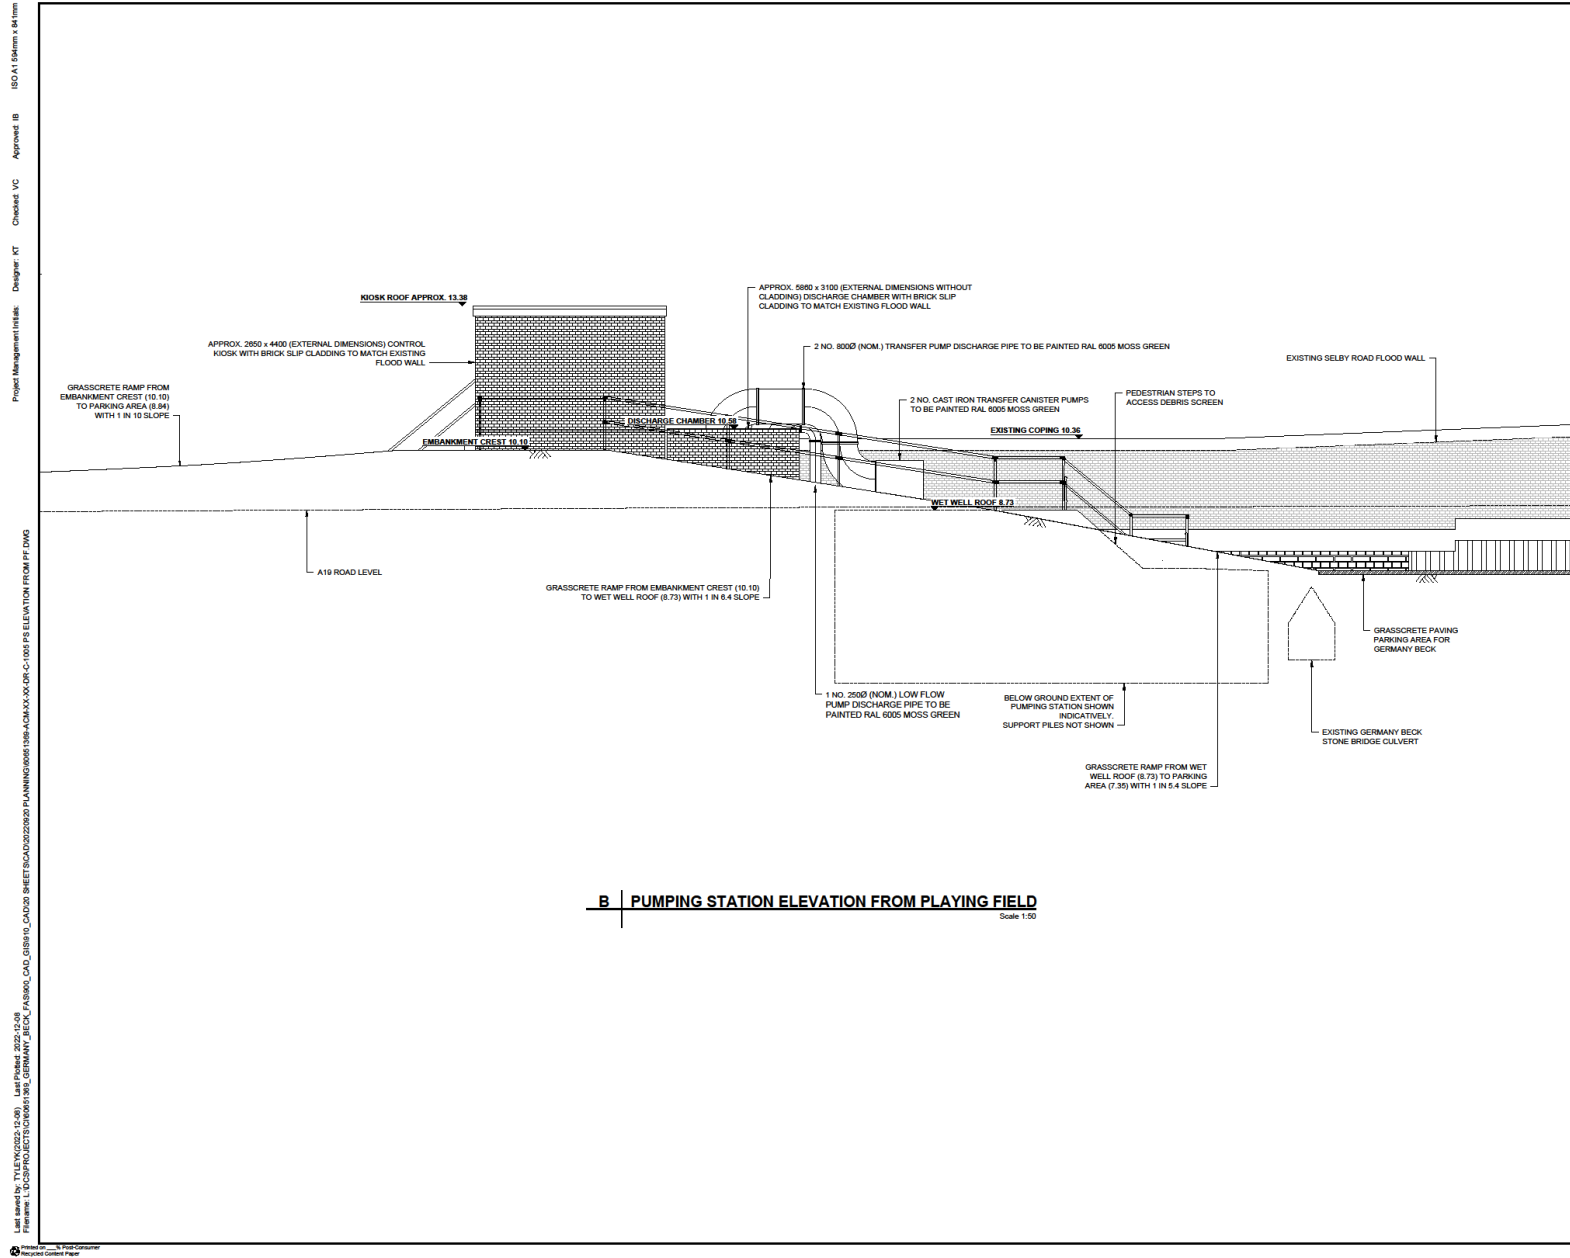

**B | PUMPING STATION ELEVATION FROM PLAYING FIELD**  
Scale: 1:50

 

**ISSUE/REVISION**

PN	DATE	FOR PLANNING
VR	DATE	DESCRIPTION
01	08/12/2022	FOR PLANNING

**PROJECT NUMBER**  
60651369


**SHEET TITLE**  
PUMPING STATION ELEVATION  
LOOKING WEST FROM PLAYING FIELD

**SHEET NUMBER**  
60651369-ACM-XX-XX-C-DR-1005

Project Management Initials: Designer: KT Checked: VC Approved: BB  
 IBD A1 194mm x 64mm  
 Last saved by: TYLEY\02021048 - Last Printed: 2022-02-08  
 Filename: L:\DCR\PROJECTS\2020\6158\_GERMANY\_BECK\_PA\60651369-ACM-XX-XX-C-DR-1005-PA-ELEVATION FROM PF DWG

This sheet has been prepared for the use of AECOM's client. It may not be used, copied, reproduced or otherwise used for any other purpose without the prior written consent of AECOM. AECOM shall not be liable for any errors or omissions in this drawing. AECOM shall not be responsible for any damage or loss of any kind arising from the use of this drawing. AECOM shall not be responsible for any damage or loss of any kind arising from the use of this drawing. AECOM shall not be responsible for any damage or loss of any kind arising from the use of this drawing.

# Pumping station North elevations

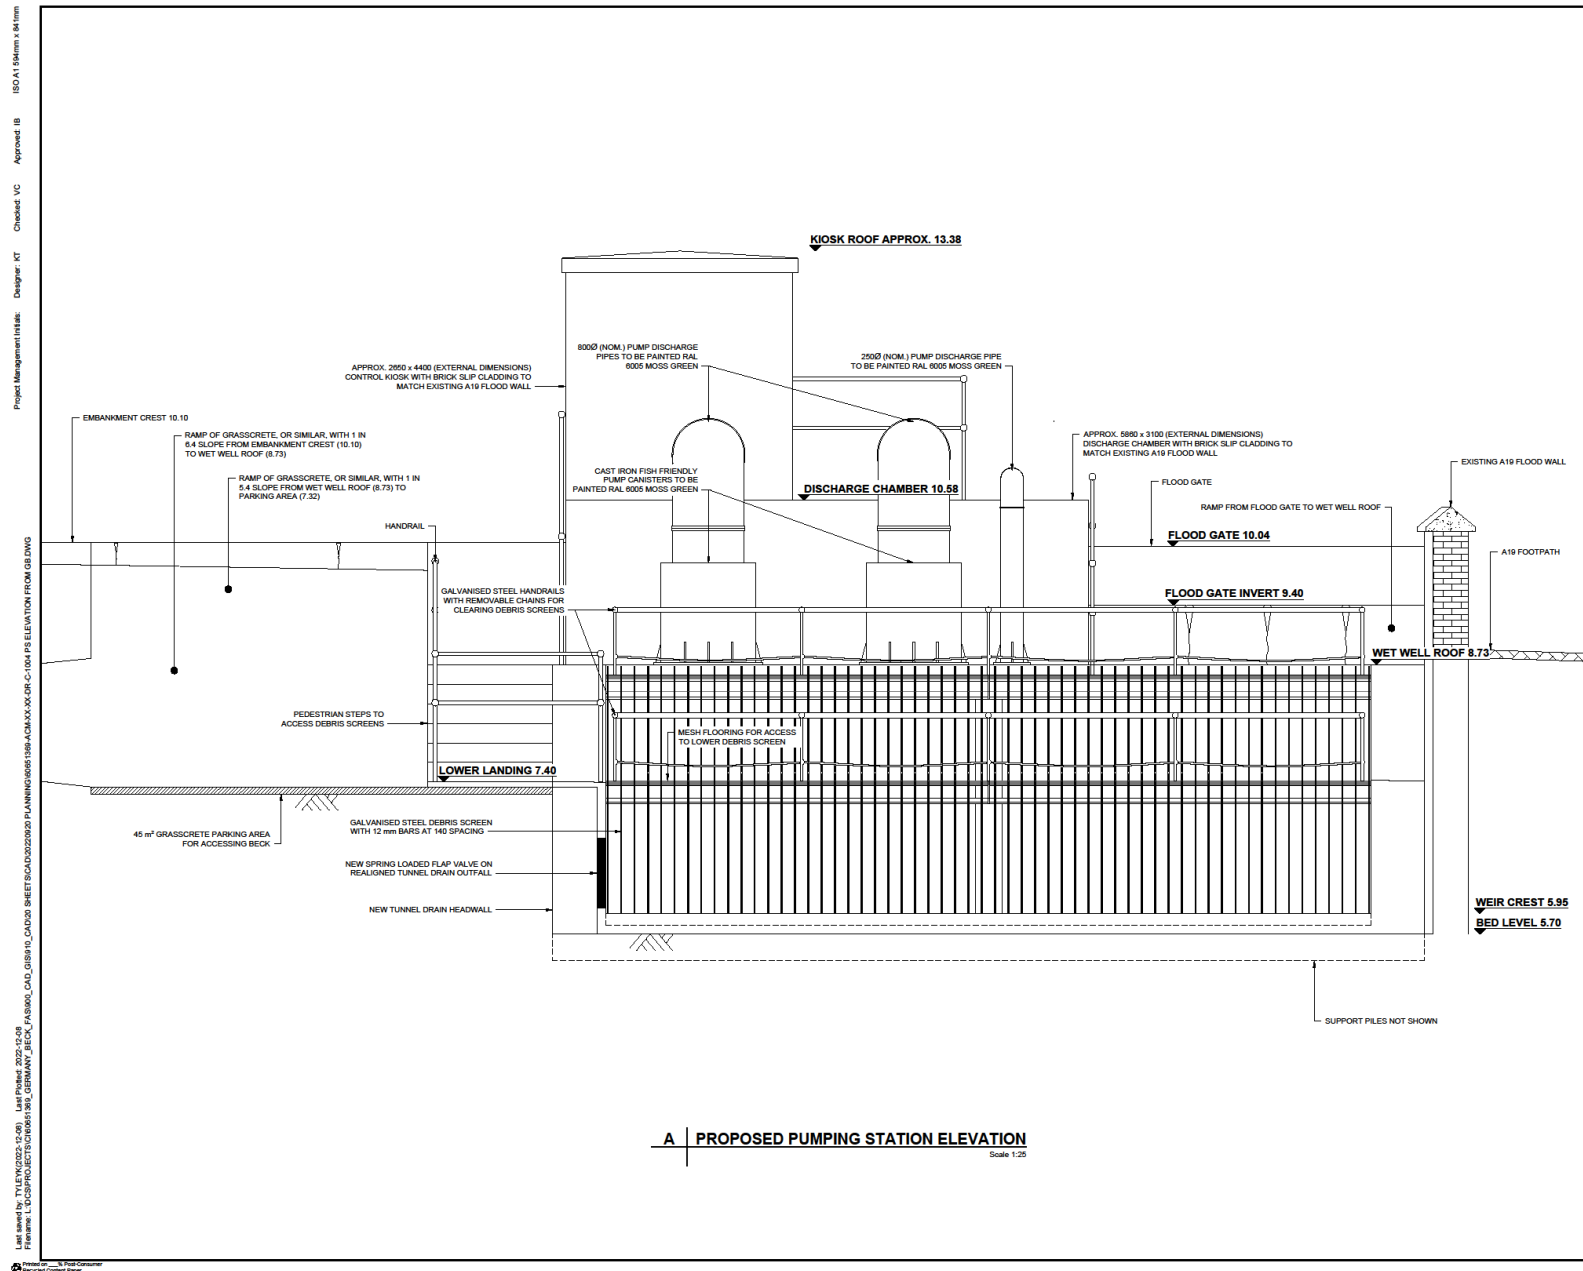

**A | PROPOSED PUMPING STATION ELEVATION**  
Scale 1:25

**ISSUE/REVISION**

NO	DATE	DESCRIPTION
PO1	08/13/22	FOR PLANNING
191	DATE	DESCRIPTION

**PROJECT NUMBER**  
60651369


**SHEET TITLE**  
PUMPING STATION ELEVATION  
LOOKING SOUTH FROM GERMANY  
BECK

**SHEET NUMBER**  
60651369-ACM-XX-XX-C-DR-1004

ISO A1 (4 sheets of A4) Size  
 Approved: JB  
 Checked: VC  
 Designer: KT  
 Project Management/Author: JB  
 Last issue for: T:\1767\2020-C-08 - Last Issue: 2020-09-08  
 Filename: L:\DCP\PROJECTS\01906190\_GERMANY\_BECK\_PAS900\_CAD\_GIS\10\_CAD\03 SHEET\03\03\2020\PLANNING\60651369-ACM-XX-XX-C-DR-C-1004\_P8 ELEVATION FROM JB.DWG  
 This drawing has been prepared for the use of AECOM's client. It may not be used, modified, reproduced or otherwise disseminated without the prior written consent of AECOM. AECOM accepts no responsibility for the accuracy or completeness of the information provided herein. AECOM shall not be liable for any loss or damage, including consequential, special or exemplary damages, arising out of the use of this drawing, even if the use of this drawing was foreseeable.

# Pumping station elevation From Main Street

ISO A1 (84mm x 84mm) Approved: B Checked: VC Designer: XT Project Management: LK: Date: 08/12/2022  
 Lead: P: J: Title: T: File Name: L:

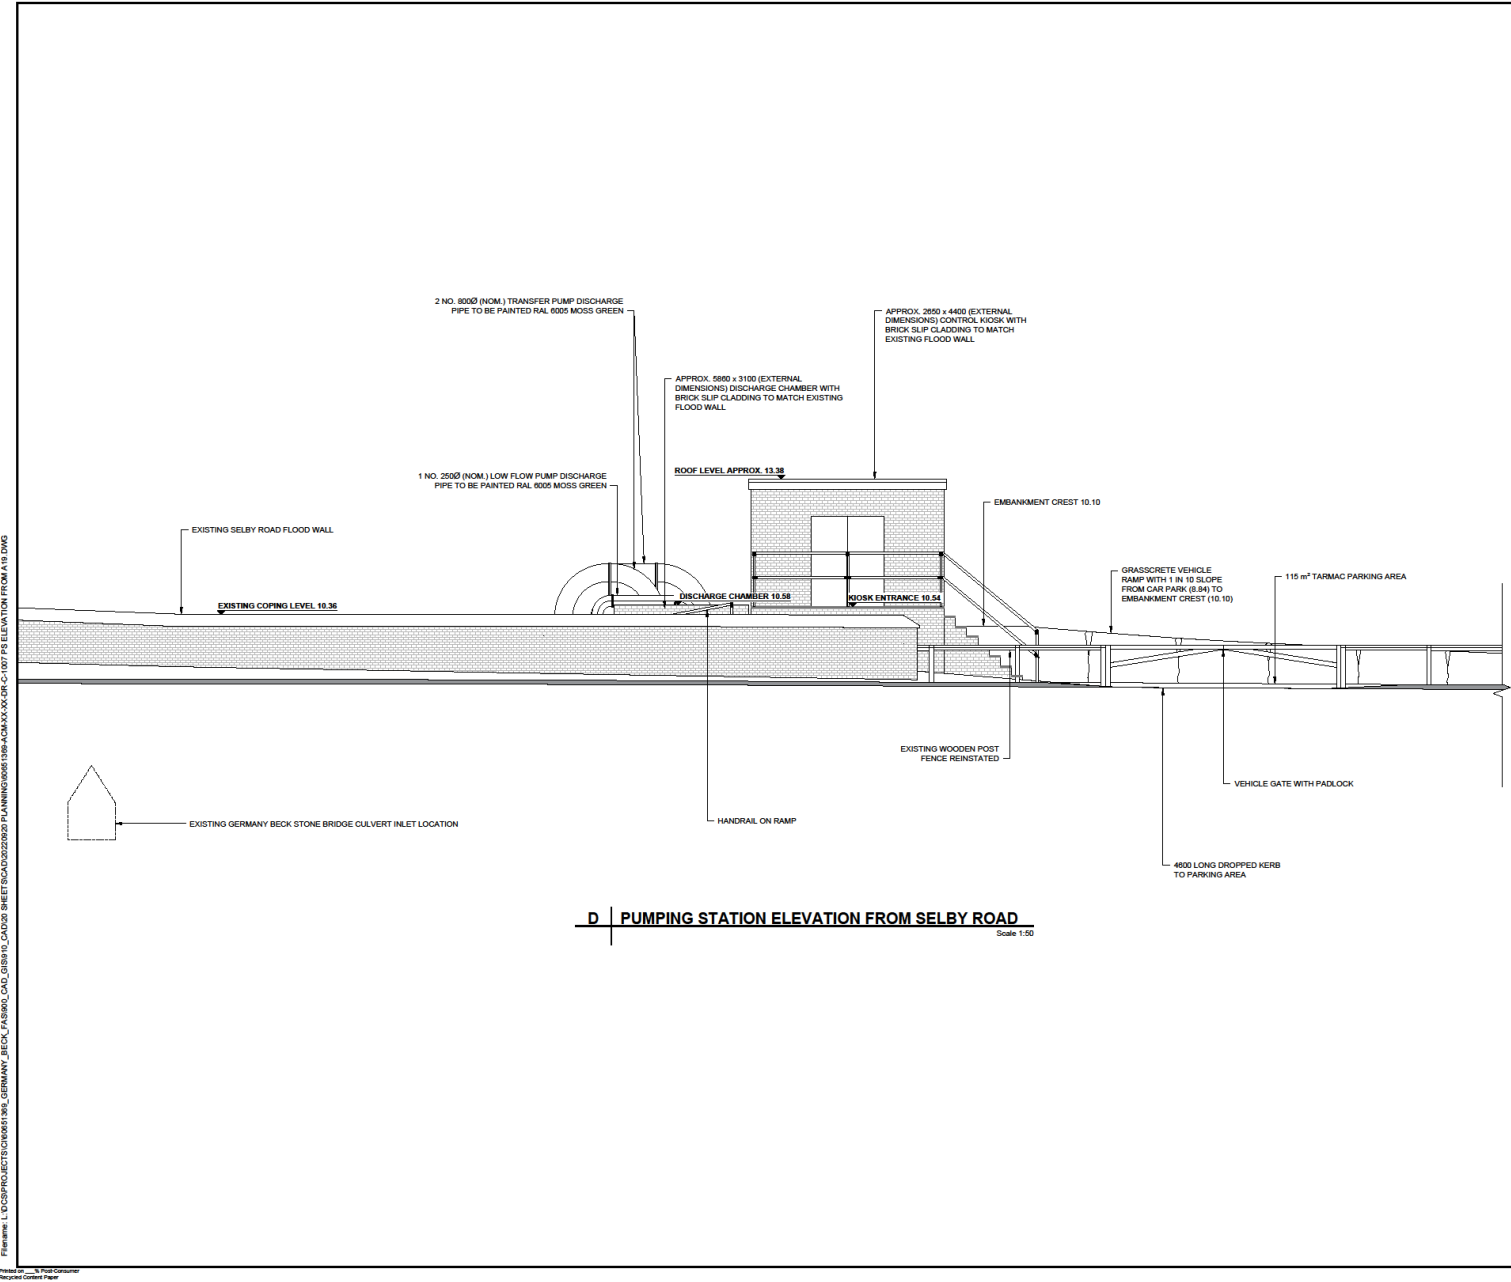


**PROJECT**  
 GERMANY BECK  
 FLOOD ALLEVIATION  
 SCHEME

**CLIENT**  
 CITY OF YORK COUNCIL  
 West Offices, Station Rise  
 York, YO1 6GA

**CONSULTANT**  
 AECOM  
 2 City Walk,  
 Leeds, LS11 8AR  
 +44(0)113-301-8400 tel.  
 www.aecom.com

 - NOTES**
- DO NOT SCALE FROM THIS DRAWING.
  - ALL DIMENSIONS IN MILLIMETRES UNLESS OTHERWISE STATED.
  - ALL LEVELS IN METRES ABOVE ORDNANCE DATUM.



FOR INFORMATION ONLY

**ISSUE/REVISION**

PR	DATE	DESCRIPTION
PR1	08/12/2022	FOR PLANNING


**PROJECT NUMBER**  
 60651369

**SHEET TITLE**  
 PUMPING STATION ELEVATION  
 LOOKING EAST FROM SELBY ROAD

**SHEET NUMBER**  
 60651369-ACM-XX-XX-C-DR-1007


This drawing has been prepared for the use of AECOM only. It may not be used for any other purpose without the written consent of AECOM. AECOM accepts no responsibility for the use of this drawing for any purpose other than that for which it was prepared. All measurements shall be taken from the datum of Ordnance Datum.

Pumping station  
South elevation

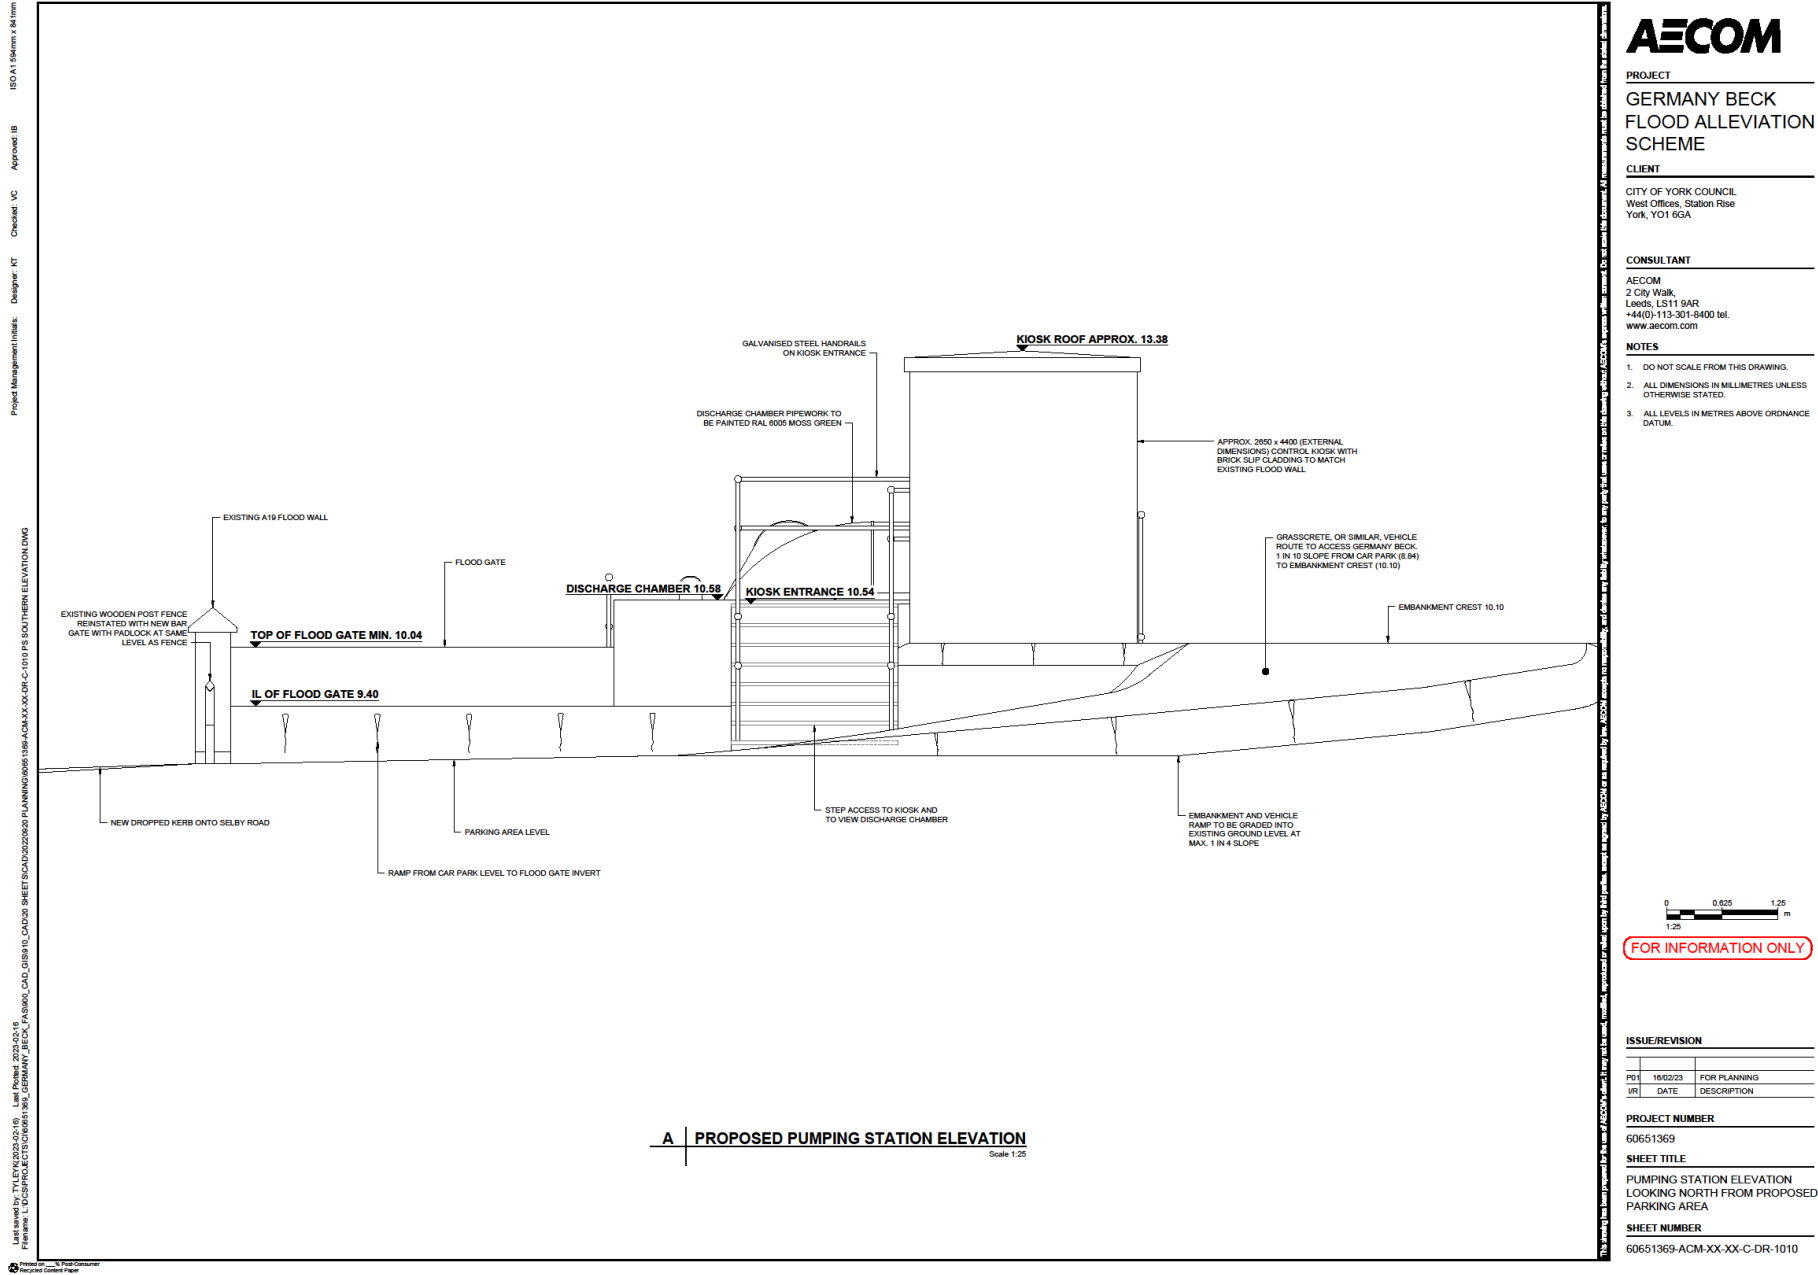

# Pumping Station section towards Main Street

Project Management/Title: Designer: RT Checked: VC Approved: JB ISO A1 50mm x 40mm  
 Planning Ref: 23/01502/01/01 - Landfill: 2023/01/25 File Name: L:\3-CONTRACTS\2023\2301502\193\_GERMANY\_BECK\_BLOCK\_FAS900\_CAD\_GIB919\_CAD200\_SHEETS\CAD20220200\_PLANNING\005\193-ACM-XX-XX-DR-C-1008\_PS\_SECTION\_TOWARDS\_A10\_DWG

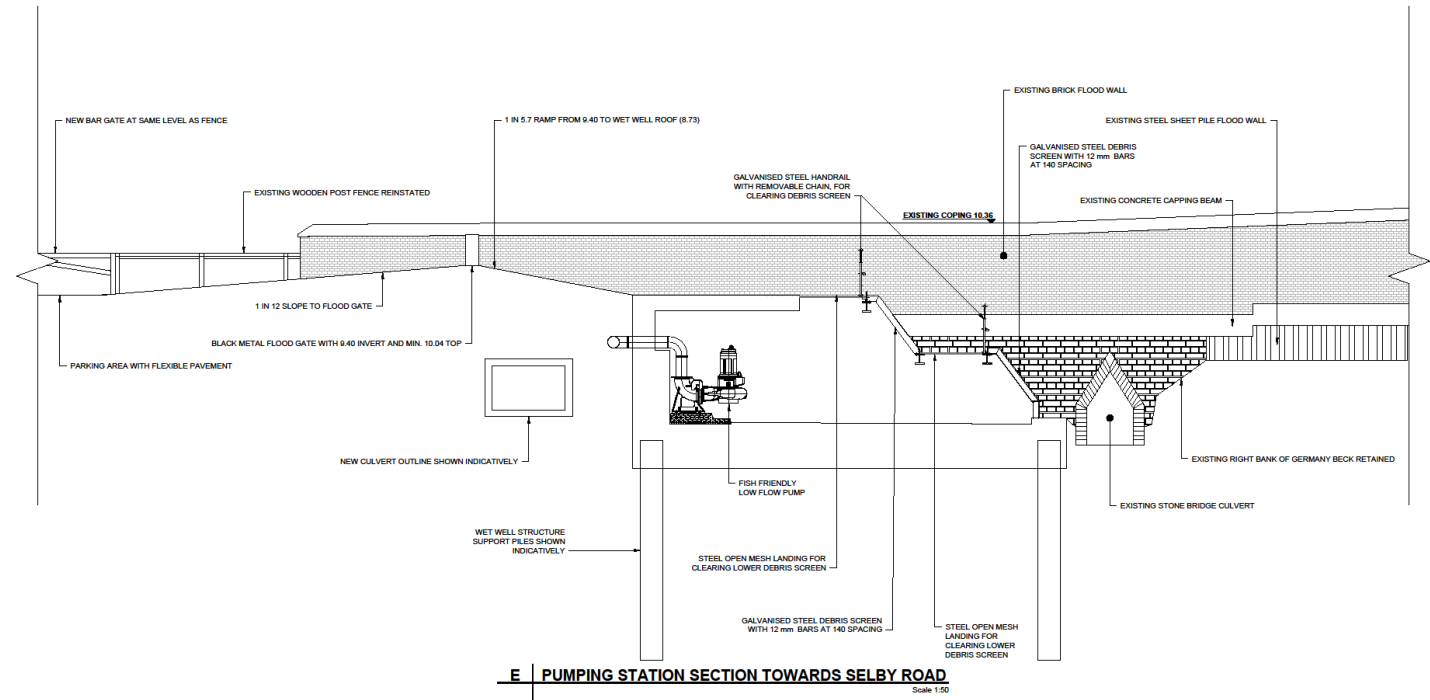

**PROJECT**  
 GERMANY BECK  
 FLOOD ALLEVIATION  
 SCHEME

**CLIENT**  
 CITY OF YORK COUNCIL  
 West Offices, Station Rise  
 York, YO1 6GA

**CONSULTANT**  
 AECOM  
 2 City Walk  
 Leeds, LS11 9AR  
 +44(0)113-301-8400 tel.  
 www.aecom.com

- NOTES**
- DO NOT SCALE FROM THIS DRAWING.
  - ALL DIMENSIONS IN MILLIMETRES UNLESS OTHERWISE STATED.
  - ALL LEVELS IN METRES ABOVE ORDNANCE DATUM.



**FOR INFORMATION ONLY**

ISSUE/REVISION	
NO	DESCRIPTION

PROJECT NUMBER	
60551369	


SHEET TITLE	
PUMPING STATION SECTION F LOOKING WEST TOWARDS SELBY ROAD	

SHEET NUMBER	
60551369-ACM-XX-XX-C-DR-1008	



# Pumping station section towards playing field

ISO A1 594mm x 841mm  
 Approved: IB  
 Checked: VC  
 Designer: KT  
 Project Management Initials:  
 L1: saved by: TYLEY(2023-12-02), User Profile: 2023-12-08  
 Filename: L:\CDS\PROJECTS\061951\_SBI\_GERMANY\_BECK\_PUMPING\_STATION\_SECTION\_TOWARDS\_PLAYING\_FIELD.DWG

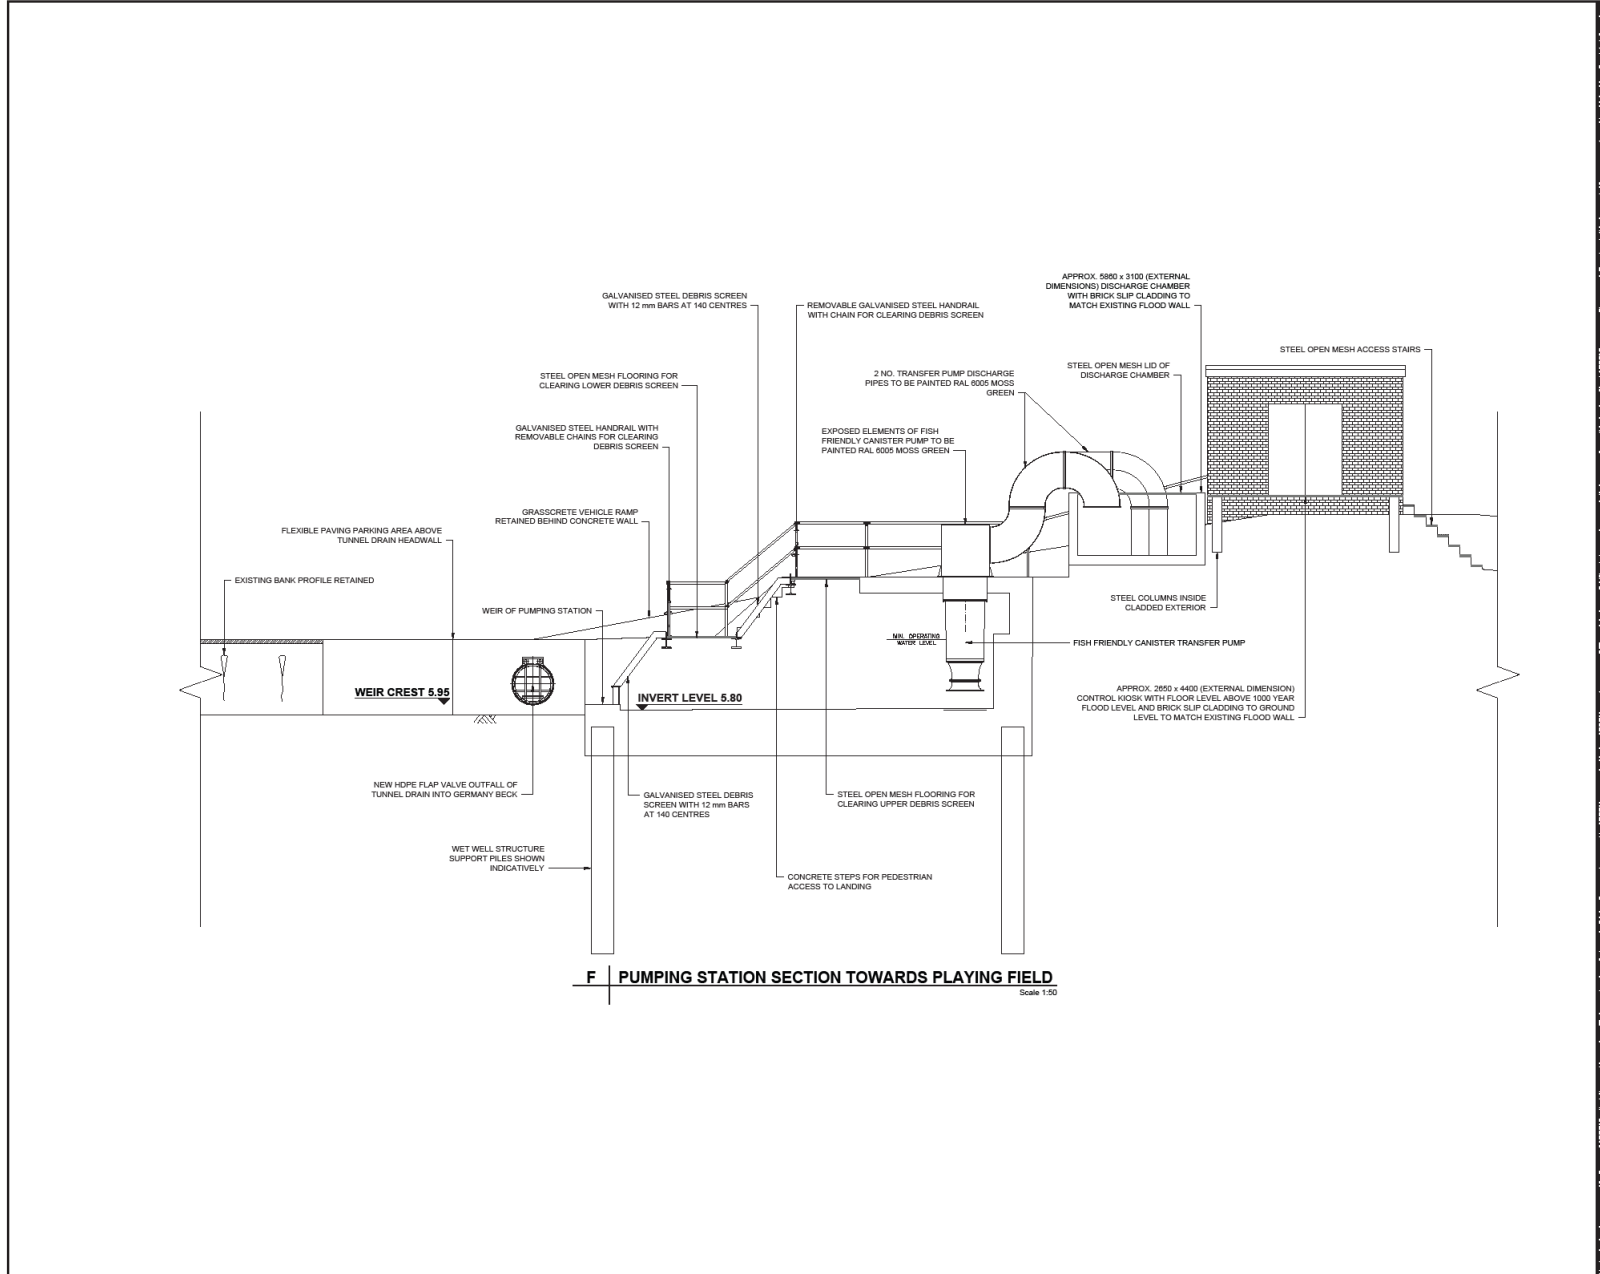

**PROJECT**  
 GERMANY BECK  
 FLOOD ALLEVIATION  
 SCHEME

**CLIENT**  
 CITY OF YORK COUNCIL  
 West Offices, Station Rise  
 York, YO1 6GA

**CONSULTANT**  
 AECOM  
 2 City Walk  
 Leeds, LS11 1AR  
 +44(0)113-301-8400 tel.  
 www.aecom.com

- NOTES**
- DO NOT SCALE FROM THIS DRAWING.
  - ALL DIMENSIONS IN MILLIMETRES UNLESS OTHERWISE STATED.
  - ALL LEVELS IN METRES ABOVE ORDNANCE DATUM.



FOR INFORMATION ONLY

**ISSUE/REVISION**

NO	DATE	DESCRIPTION
P01	08/12/2022	FOR PLANNING
NR		


**PROJECT NUMBER**  
 60651369

**SHEET TITLE**  
 PUMPING STATION SECTION F  
 LOOKING EAST TOWARDS FIELD


**SHEET NUMBER**  
 60651369-ACM-XX-XX-C-DR-1009

# Outfall elevation (west side of Main Street)

Project Management Initials: Designer: KT Check out: VC Approved: IB ISO A1 594mm x 841mm  
 Last saved by: TYLEY, N (2023, 12-20) Last Printed: 2023-12-09  
 File name: L:\DCS\PROJECTS\060661366\_GERMANY\_BECK\_FAS890\_CAD\_081919\_CAD09\_SHEET\060661366\_GERMANY\_BECK\_FAS890\_CAD\_081919\_CAD09\_PLANNING\060661366\_ACM-XX-XX-CR-C-1006\_OUTFALL ELEVATION.DWG

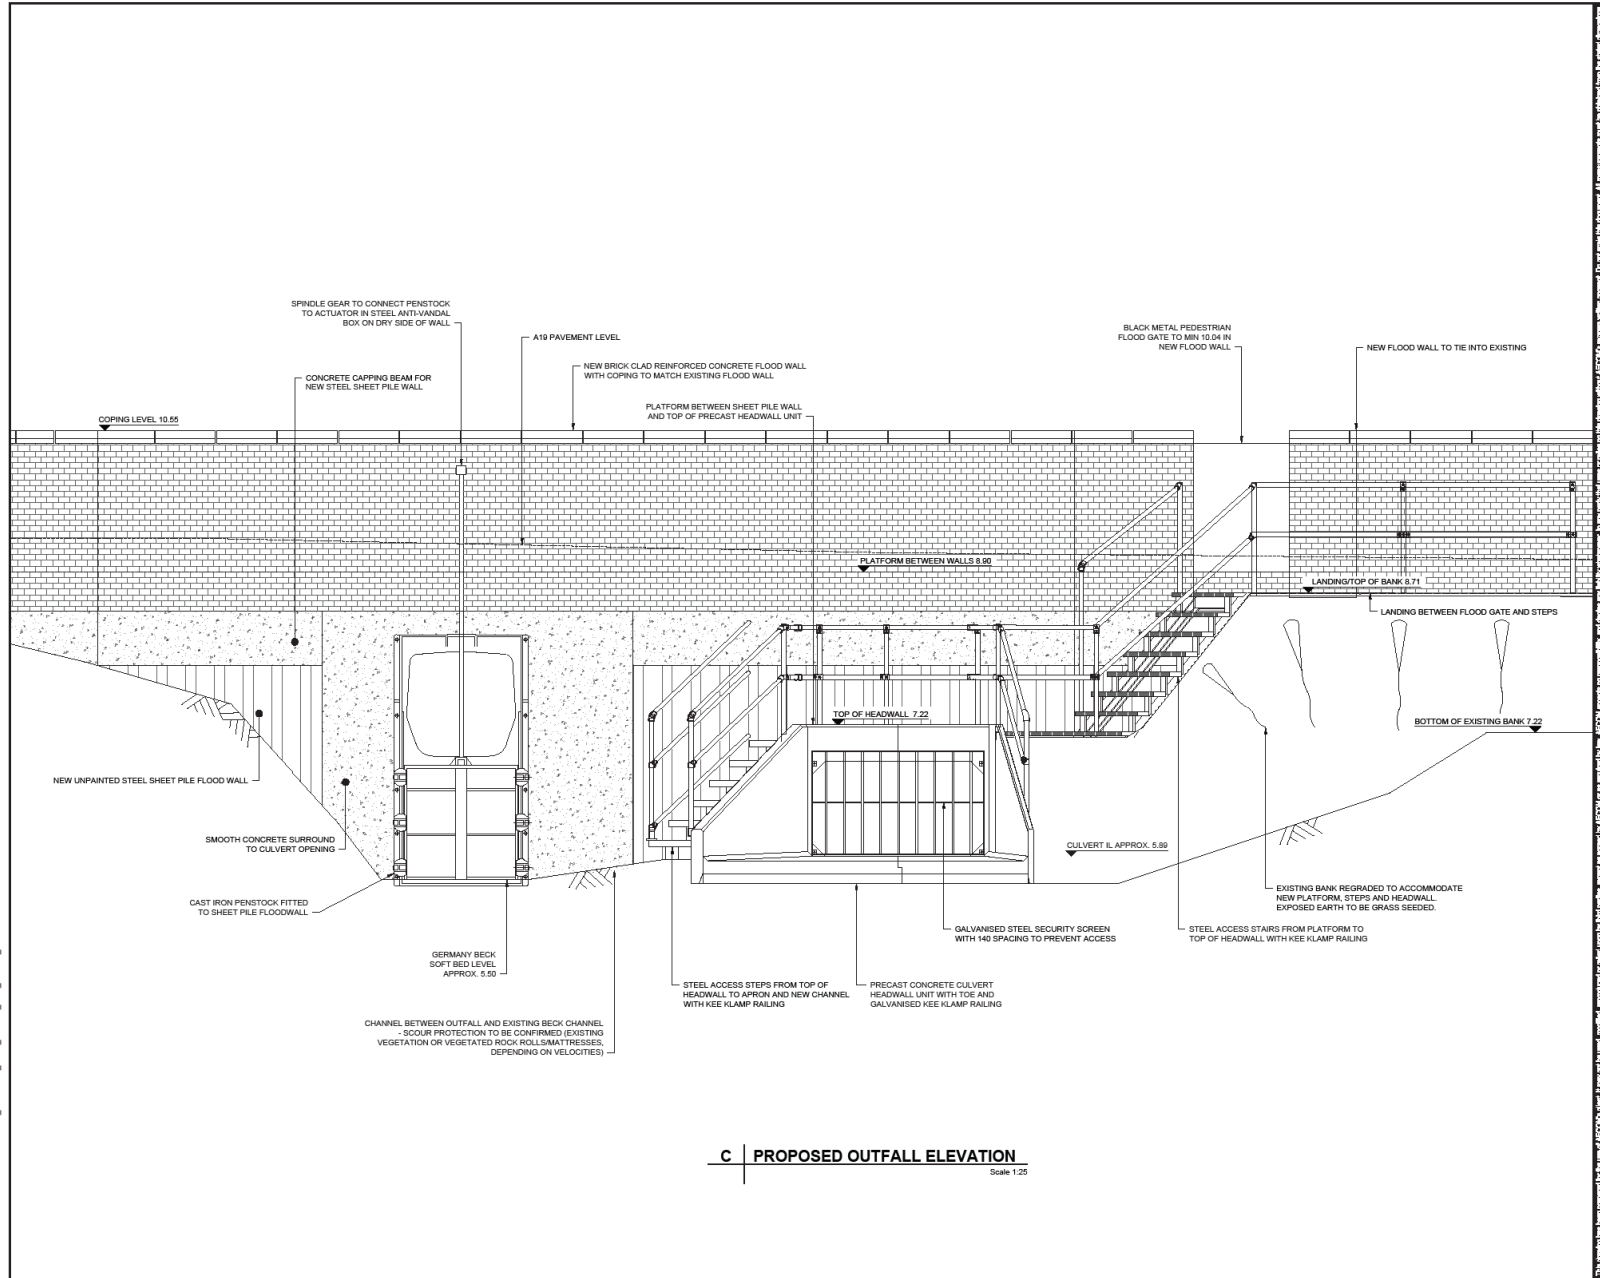

**C | PROPOSED OUTFALL ELEVATION**  
Scale 1:25

 

FOR INFORMATION ONLY

**ISSUE/REVISION**

NO	DATE	DESCRIPTION
P01	08/12/22	FOR PLANNING
IR1		

**PROJECT NUMBER**  
60651369

**SHEET TITLE**  
OUTFALL ELEVATION


**SHEET NUMBER**  
60651369-ACM-XX-XX-C-DR-1006



# Landing Lane embankment

Project Management (M/Ref): Designer: KT Check: VC Approved: IB ISO A1 594mm x 841mm

Last saved by: TYLEY(2023:12:08) Last Printed: 2023:12:08  
 Filename: L:\CD\PROJECTS\06051369\_GENERAL\_ARRANGEMENTS\06051369\_GENERAL\_ARRANGEMENTS.DWG

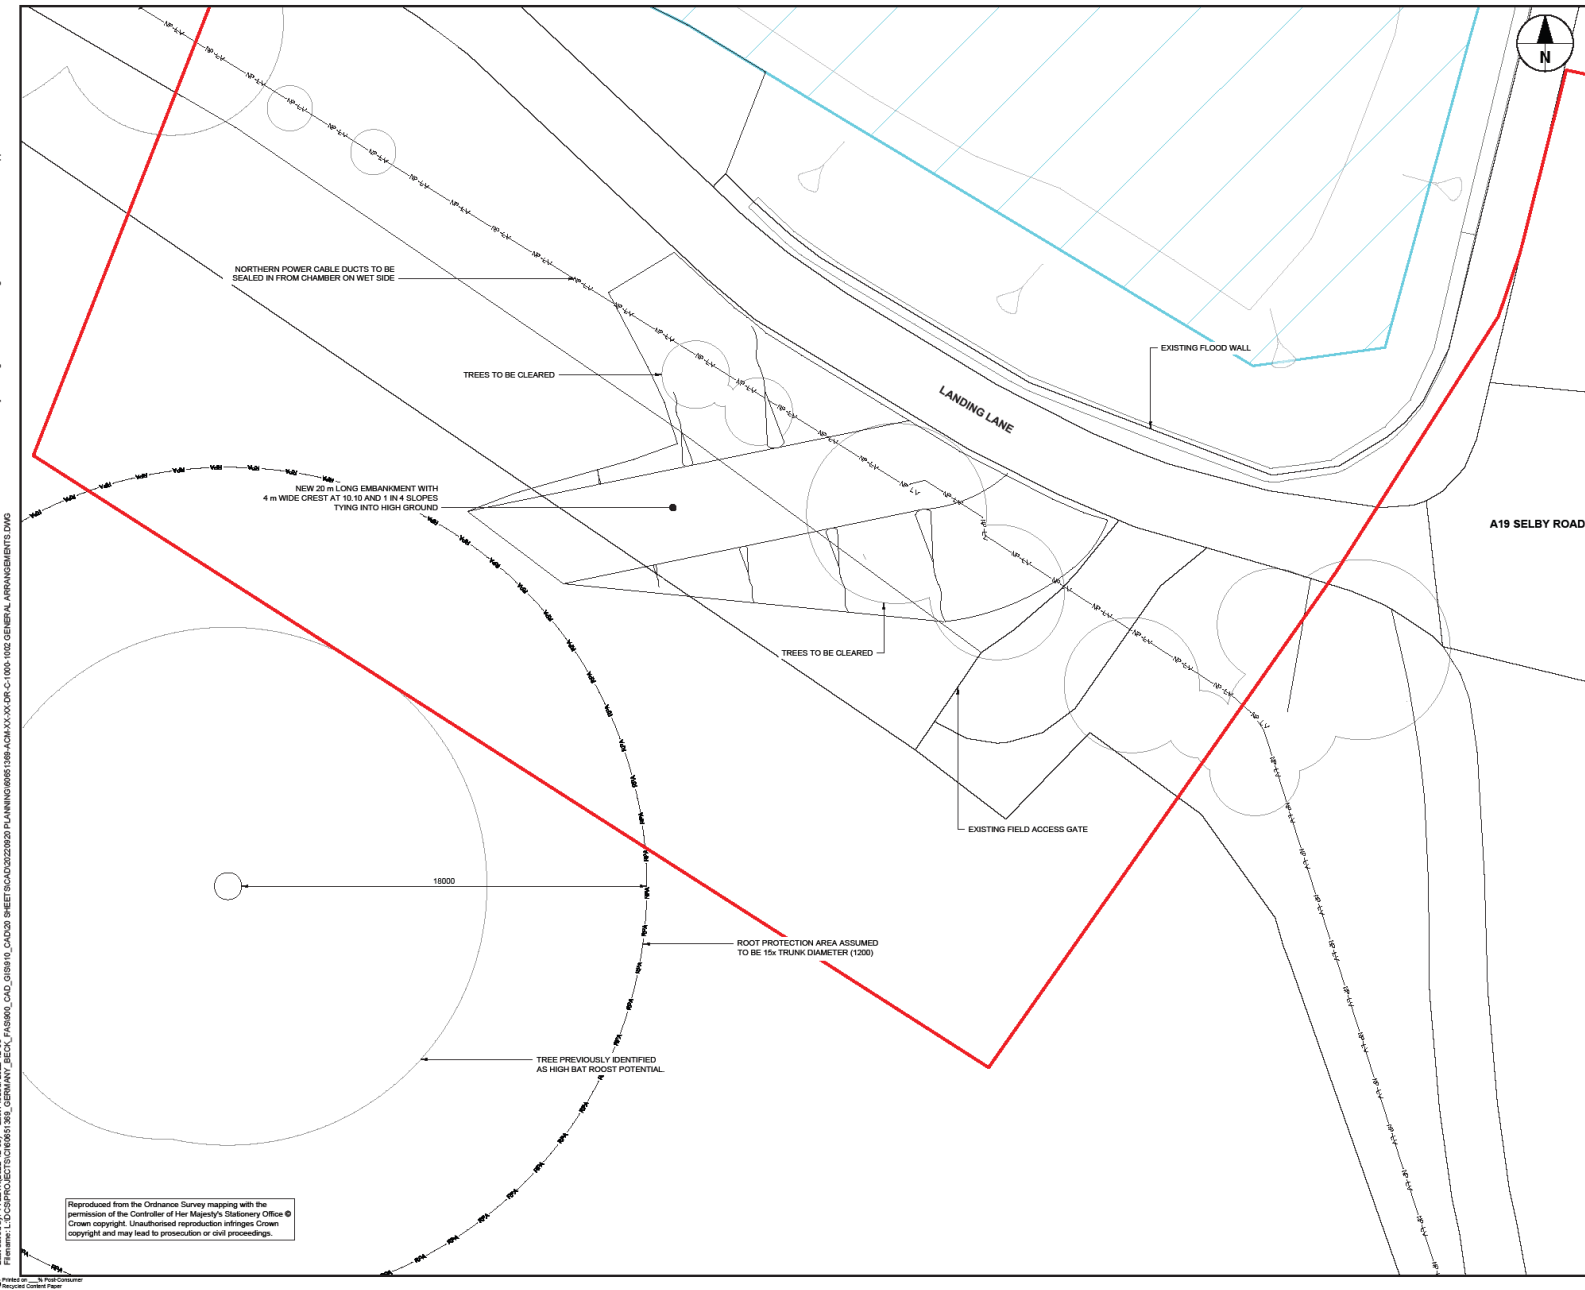

Reproduced from the Ordnance Survey mapping with the permission of the Controller of Her Majesty's Stationery Office. Crown copyright. Unauthorised reproduction infringes Crown copyright and may lead to prosecution or civil proceedings.



**PROJECT**  
 GERMANY BECK  
 FLOOD ALLEVIATION  
 SCHEME

**CLIENT**  
 CITY OF YORK COUNCIL  
 West Offices, Station Rise  
 York, YO1 6GA

**CONSULTANT**  
 AECOM  
 2 City Walk,  
 Leeds, LS11 9AR  
 +44(0)-113-301-8400 tel.  
 www.aecom.com

- NOTES**
- DO NOT SCALE FROM THIS DRAWING.
  - ALL DIMENSIONS IN MILLIMETRES UNLESS OTHERWISE STATED.
  - ALL LEVELS IN METRES ABOVE ORDNANCE DATUM.
  - THE FLOOD DEFENCE LEVEL OF 10.04 HAS BEEN CALCULATED FROM THE OUSE WASHLANDS MODEL 100 YEAR + 2.4% CLIMATE CHANGE ALLOWANCE FLOOD LEVEL OF 9.82 WITH 0.22 OF UNCERTAINTY.

**LEGEND**

- SITE BOUNDARY
- SITE OF SPECIAL SCIENTIFIC INTEREST



FOR INFORMATION ONLY

**ISSUE/REVISION**

NO	DATE	DESCRIPTION
01	02/12/2022	FOR PLANNING

**PROJECT NUMBER**  
60651369

**SHEET TITLE**  
GENERAL ARRANGEMENT  
LANDING LANE EMBANKMENT

**SHEET NUMBER**  
60651369-ACM-XX-XX-DR-C-1002