


ANNEX 1

- NOTES:
- THE DRAWINGS ARE TO BE READ IN CONJUNCTION WITH ALL OTHER ACCOMPANYING FRP DRAWINGS, SCHEDULES & SPECIFICATION DOCUMENTS
 - ALL DIMENSIONS IN MILLIMETRES UNLESS OTHERWISE NOTED.
 - THE DRAWINGS ARE NOT TO BE SCALED FROM.
 - ALL ROUTES ARE TO BE CHECKED ON SITE PRIOR TO THE COMMENCEMENT OF WORKS.
 - ALL PIPEWORK, DUCTWORK, CONTAINMENT & PLANT TO BE INSTALLED IN ACCORDANCE WITH THE MANUFACTURER'S RECOMMENDATIONS AND GUIDELINES.
 - ALL SERVICES ROUTES ARE TO BE AGREED BETWEEN THE DESIGN TEAM AND CLIENT PRIOR TO INSTALLATION AND TO BE CHECKED ON SITE PRIOR TO THE COMMENCEMENT OF WORKS.

- LEGEND
- FIRE ALARM**
- FIRE ALARM CONTROL PANEL
 - FIRE ALARM INTERFACE UNIT
 - MANUAL CALL POINT
 - WALL MOUNTED SOUNDER BEACON
 - SMOKE DETECTOR
 - SMOKE DETECTOR WITHIN CEILING VOID
 - SMOKE DETECTOR WITHIN ROOF VOID
 - SMOKE DETECTOR WITH SOUNDER BASE
 - SMOKE DETECTOR WITH SOUNDER BASE/BEACON
 - SMOKE DETECTOR WITH FLASHING BEACON
 - HEAT DETECTOR WITH SOUNDER BASE/BEACON
 - HEAT DETECTOR WITH FLASHING BEACON
 - CEILING MOUNTED FLASHING BEACON
- CCTV**
- PTZ PTZ DOME CCTV CAMERA
 - MINI DOME CCTV CAMERA
- INTRUDER ALARM**
- INTRUDER ALARM PANEL
 - DOOR CONTACT
 - DUAL TECH DETECTOR
 - TMD DETECTOR
 - EXTERNAL SOUNDER
 - KEYPAD
- DISABLED WC ALARM**
- REPEAT LAMP UNIT - WALL MOUNTED
 - DISABLED ALARM PULL SWITCH
 - DISABLED ALARM RESET BUTTON
- VOICE ANNUNCIATION (FIS)**
- CEILING MOUNTED RECESSED FIRE DOME SPEAKER
 - WALL MOUNTED RECESSED FIRE DOME SPEAKER

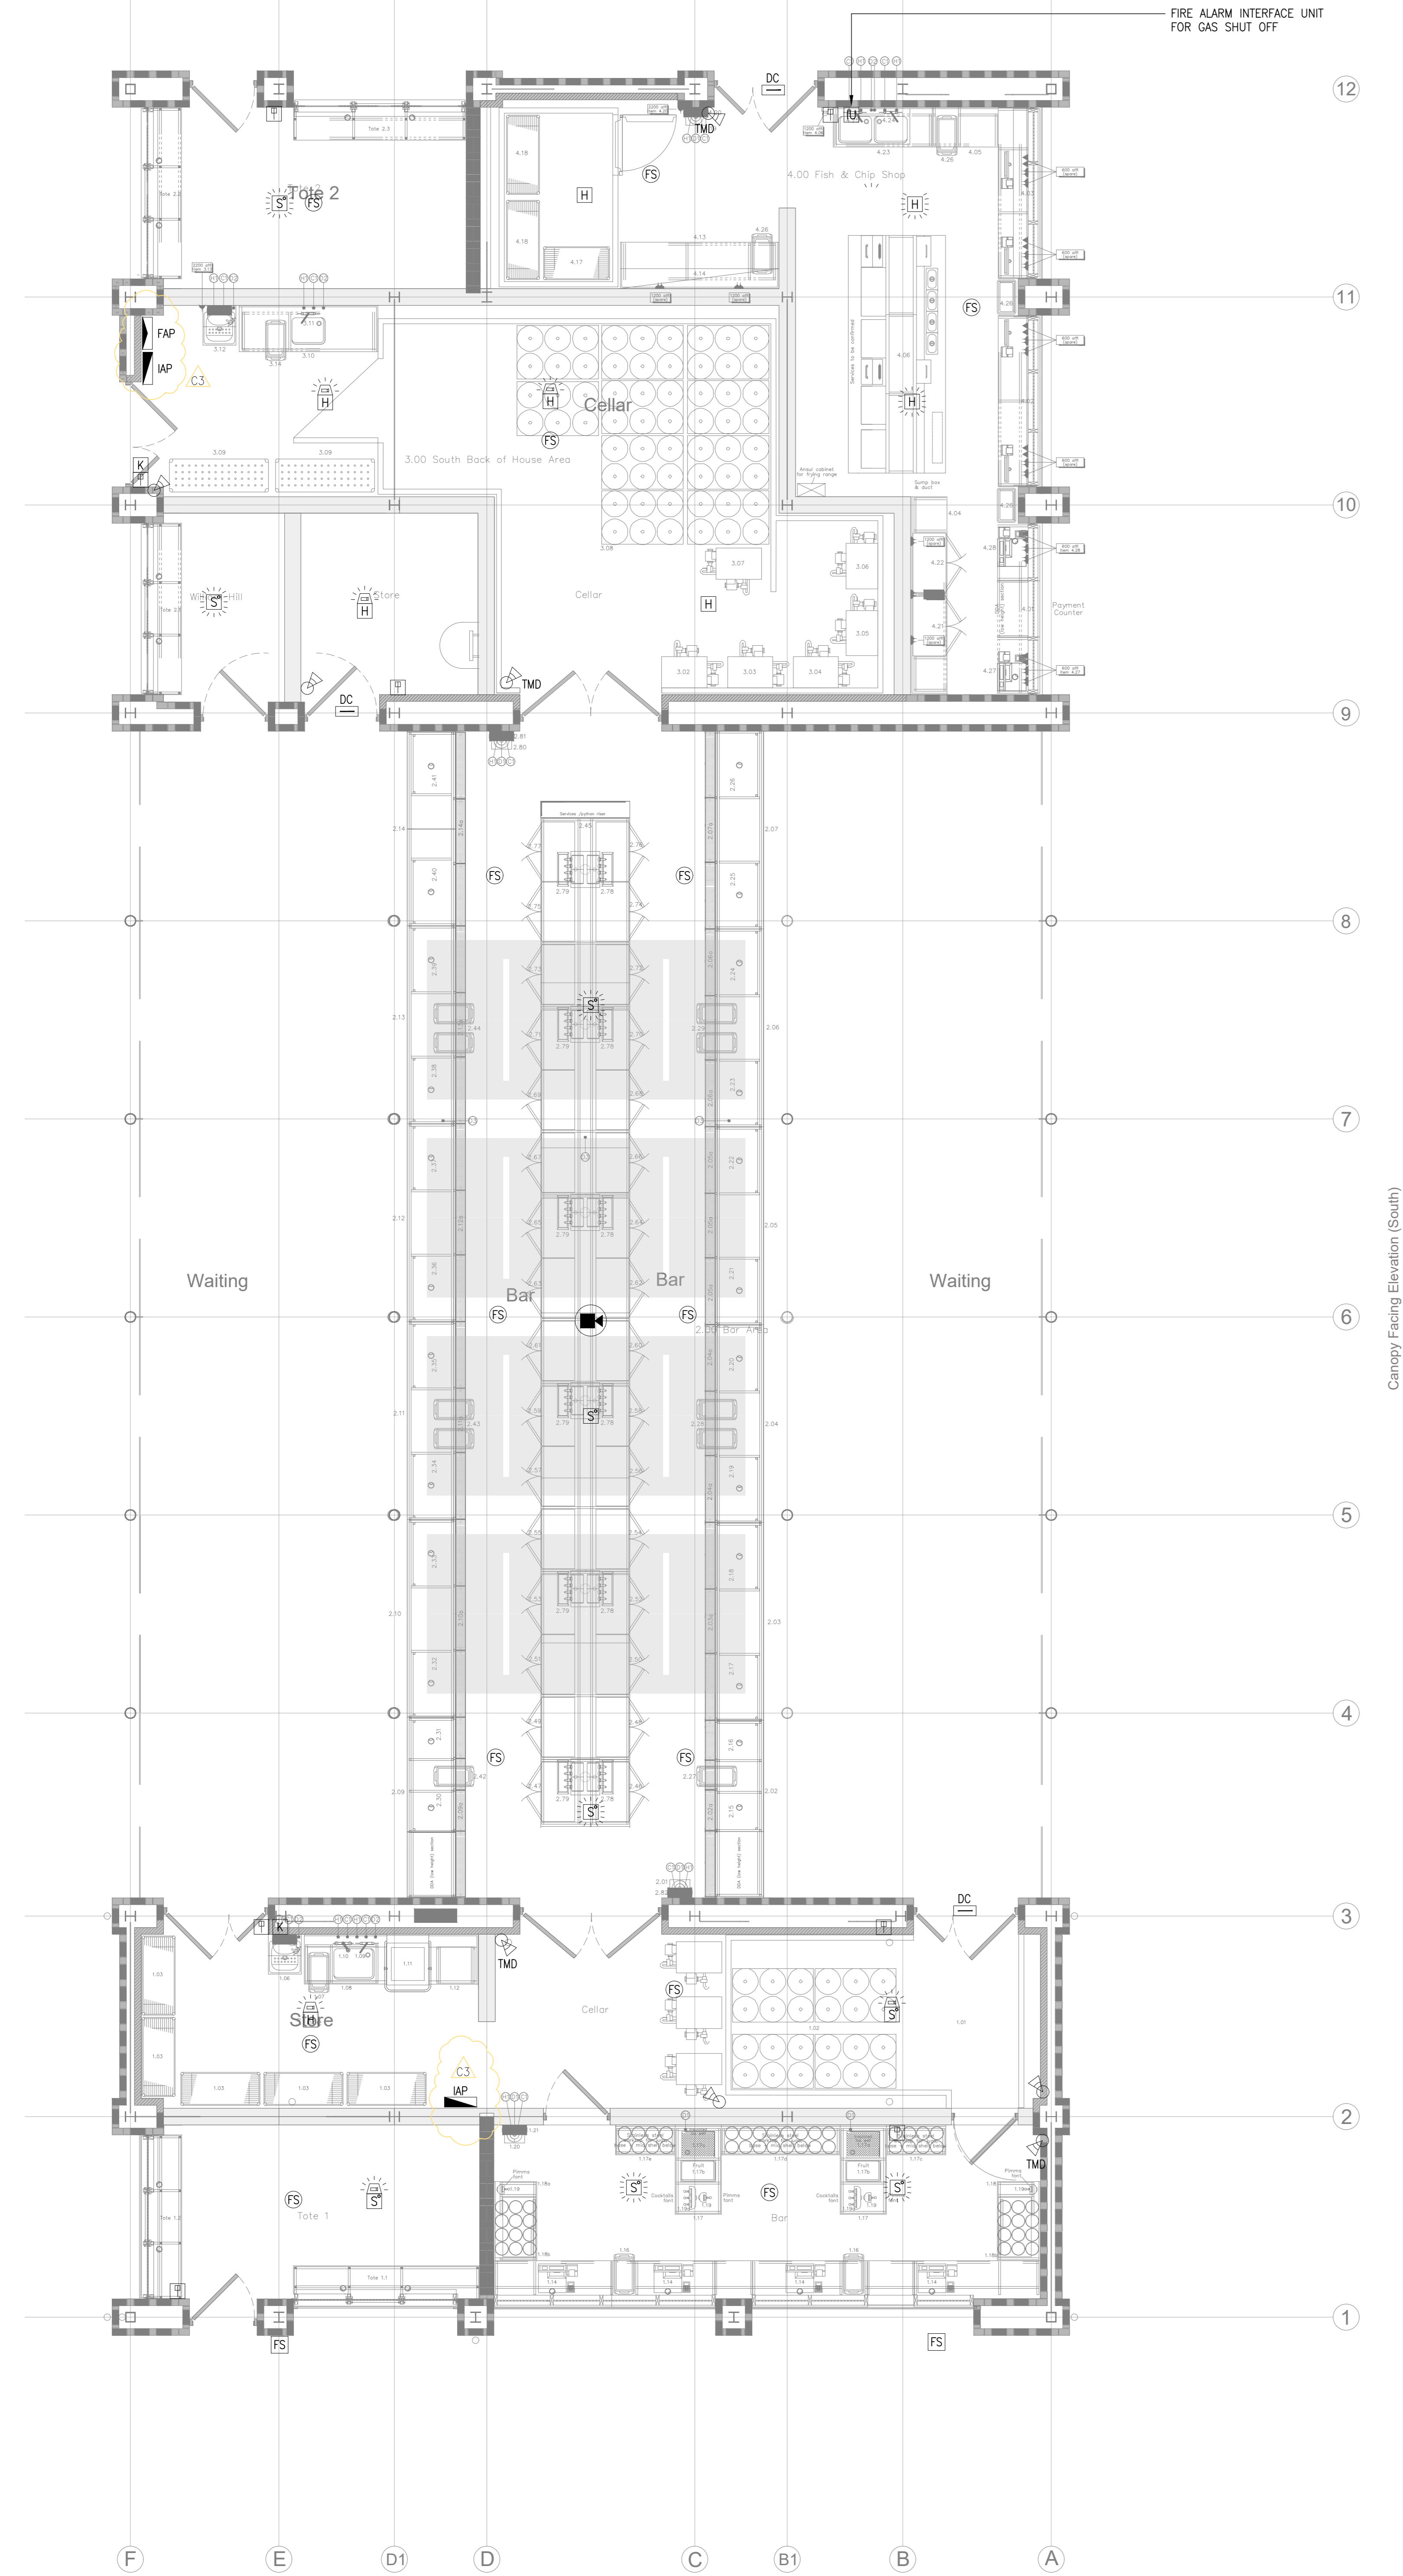


Knaresmire Facing Elevation (North)

Canopy Facing Elevation (South)

Knaresmire Facing Elevation (North)


Canopy Facing Elevation (South)

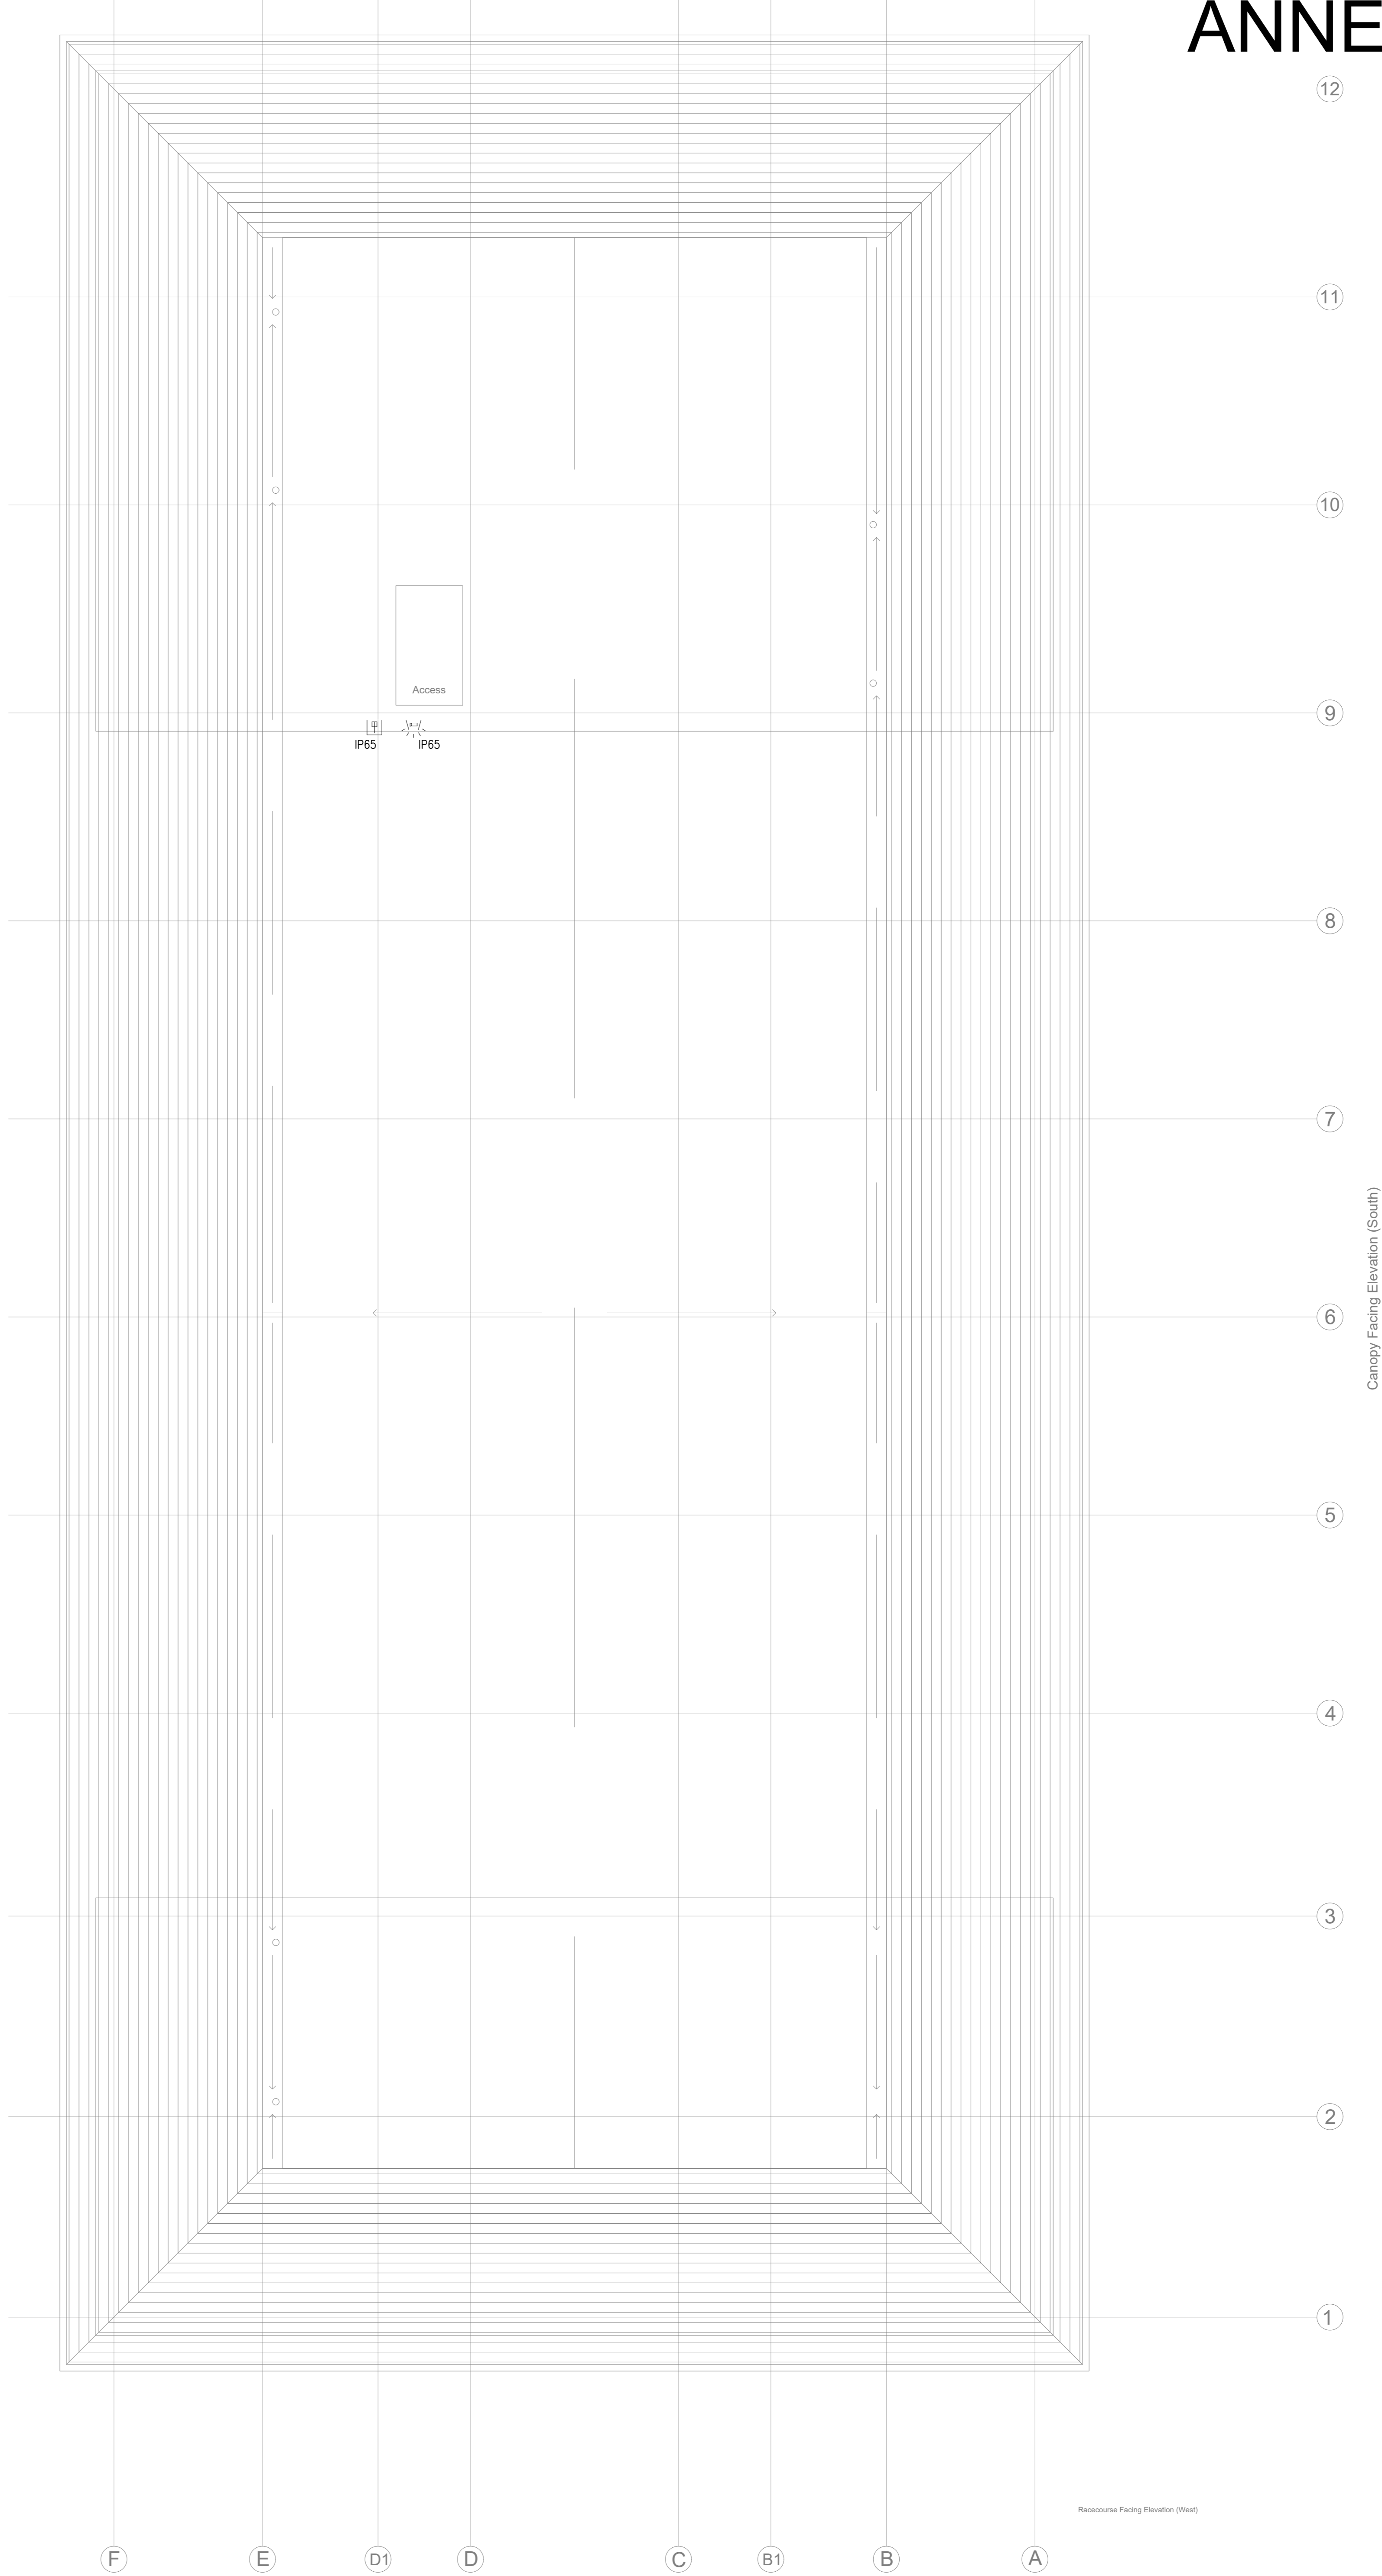

ROOF PLAN
 PROPOSED ROBERTO BAR PAVILION

C3	INTRUDER ALARM PANELS x2 & FIRE ALARM PANEL RELOCATED	29.02.24	PT
C2	SPEAKERS ADDED TO SPECIALIST REQUIREMENTS	14.02.24	PT
C1	CONTRACT ISSUE	12.01.24	PT

CONTRACT



York Racecourse
 Knaresmire Road
 York
 YO23 1EX

tel: 01904 620911
 enquiries@yorkracecourse.co.uk



Horizon
 Building Services Consultants Ltd

email: engineers@horizon.co.uk
 tel: 01904 622223
 web: www.horizon.co.uk

Horizon Building Services Consultants Ltd
 54 Boston Street
 York YO24 1AP

CLIENT YORK RACECOURSE

PROJECT YORK RACECOURSE SOUTHERN END MASTERPLAN

TITLE ELECTRICAL SERVICES ROBERTO BAR FIRE ALARM, PAVA AND SECURITY LAYOUT

SCALE: 1:50 @ A0 DATE: JAN 2024
 DRAWN: RG ENGINEER: KH
 CHECKED: APPROVED: