

Drawing Status

The contractor is responsible for checking and verifying all site dimensions and discrepancies should be reported to the designer prior to commencement on site.


The contractor is also responsible for checking this drawing against all other specialist drawings provided.

All work to be carried out strictly in accordance with the Building Regulations

© This drawing remains the copyright of Applied Design Partnership Ltd



Ground Floor Plan
Scale 1:100

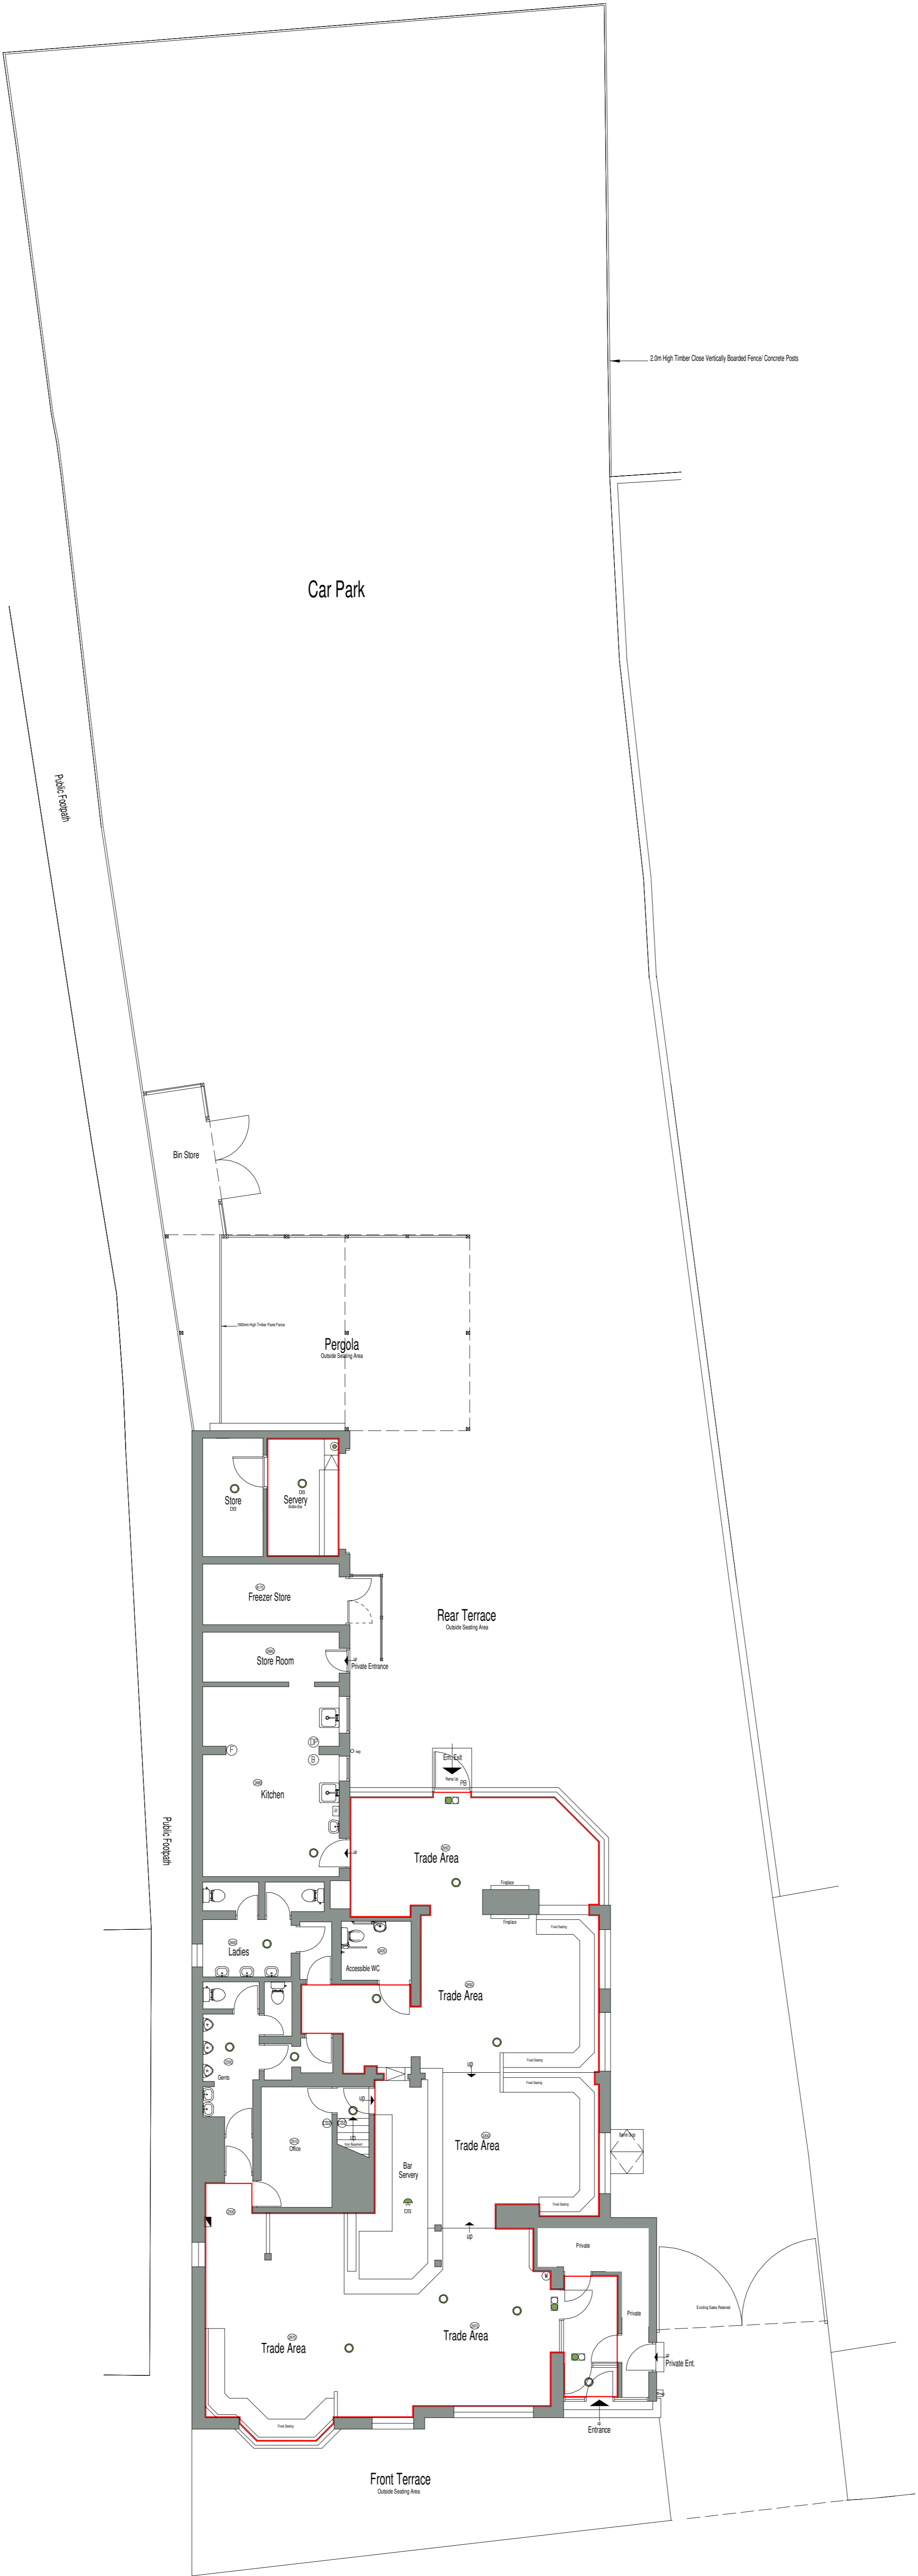


FIRE SAFETY	
F1030S	Fire Resistant Door (30min) - Fit with Self-Closing Device, Glass View & Aluminium Strip, No Narrow Panel
FB	Push Bar Emergency Together With A NY Notice Positioned Below The Push Bar
VP	Vision Panel Measuring At Least 450x450mm (Unless Otherwise Stated)
N	Water Extinguisher 9L Capacity (Unless Otherwise Stated)
F	Foam Extinguisher 6L Capacity (Unless Otherwise Stated)
FP	Dry Powder Extinguisher 6L Capacity (Unless Otherwise Stated)
B	Fire Barret (1000 /1000mm Unless Otherwise Stated)
EDS	Carbon Dioxide Extinguisher 4.5kg Capacity Unless (Otherwise Stated)
FRG	Fire Resistant Glass
IP	Fire Alarm/Zone Indicator Panel
AP	Fire Alarm Actuating Point
AS	Fire Alarm Sounder
DS	Automatic Fire Detector-Smoke
DH	Automatic Fire Detector-Heat
ELU	Emergency Lighting Unit
ES	Illuminated Exit Sign (Running Man Symbol)
EXISTING INSTALLATION TO REMAIN AS EXISTING	



Site Location Plan
Scale 1:1250

Licensable Activities May Take Place in All Public Areas
Unless the Premises Licence Specifies Otherwise



Applied Design Partnership Ltd
Project Management • Interior Design • Architecture
25a WICKHAM LANE, PRUDEN, WEST YORKSHIRE LS16 7BN
Tel: 01973 819846
email: design@adppartnership.co.uk

Site

The White Horse
The Green, Upper Poppleton
York YO26 6DF

Title

Licensing Submission Drawing

Drawing Ref.	Drawing No.	Revision
	1198-05	

Scale	Drawn	Date
1:100 @ A0	DM	